


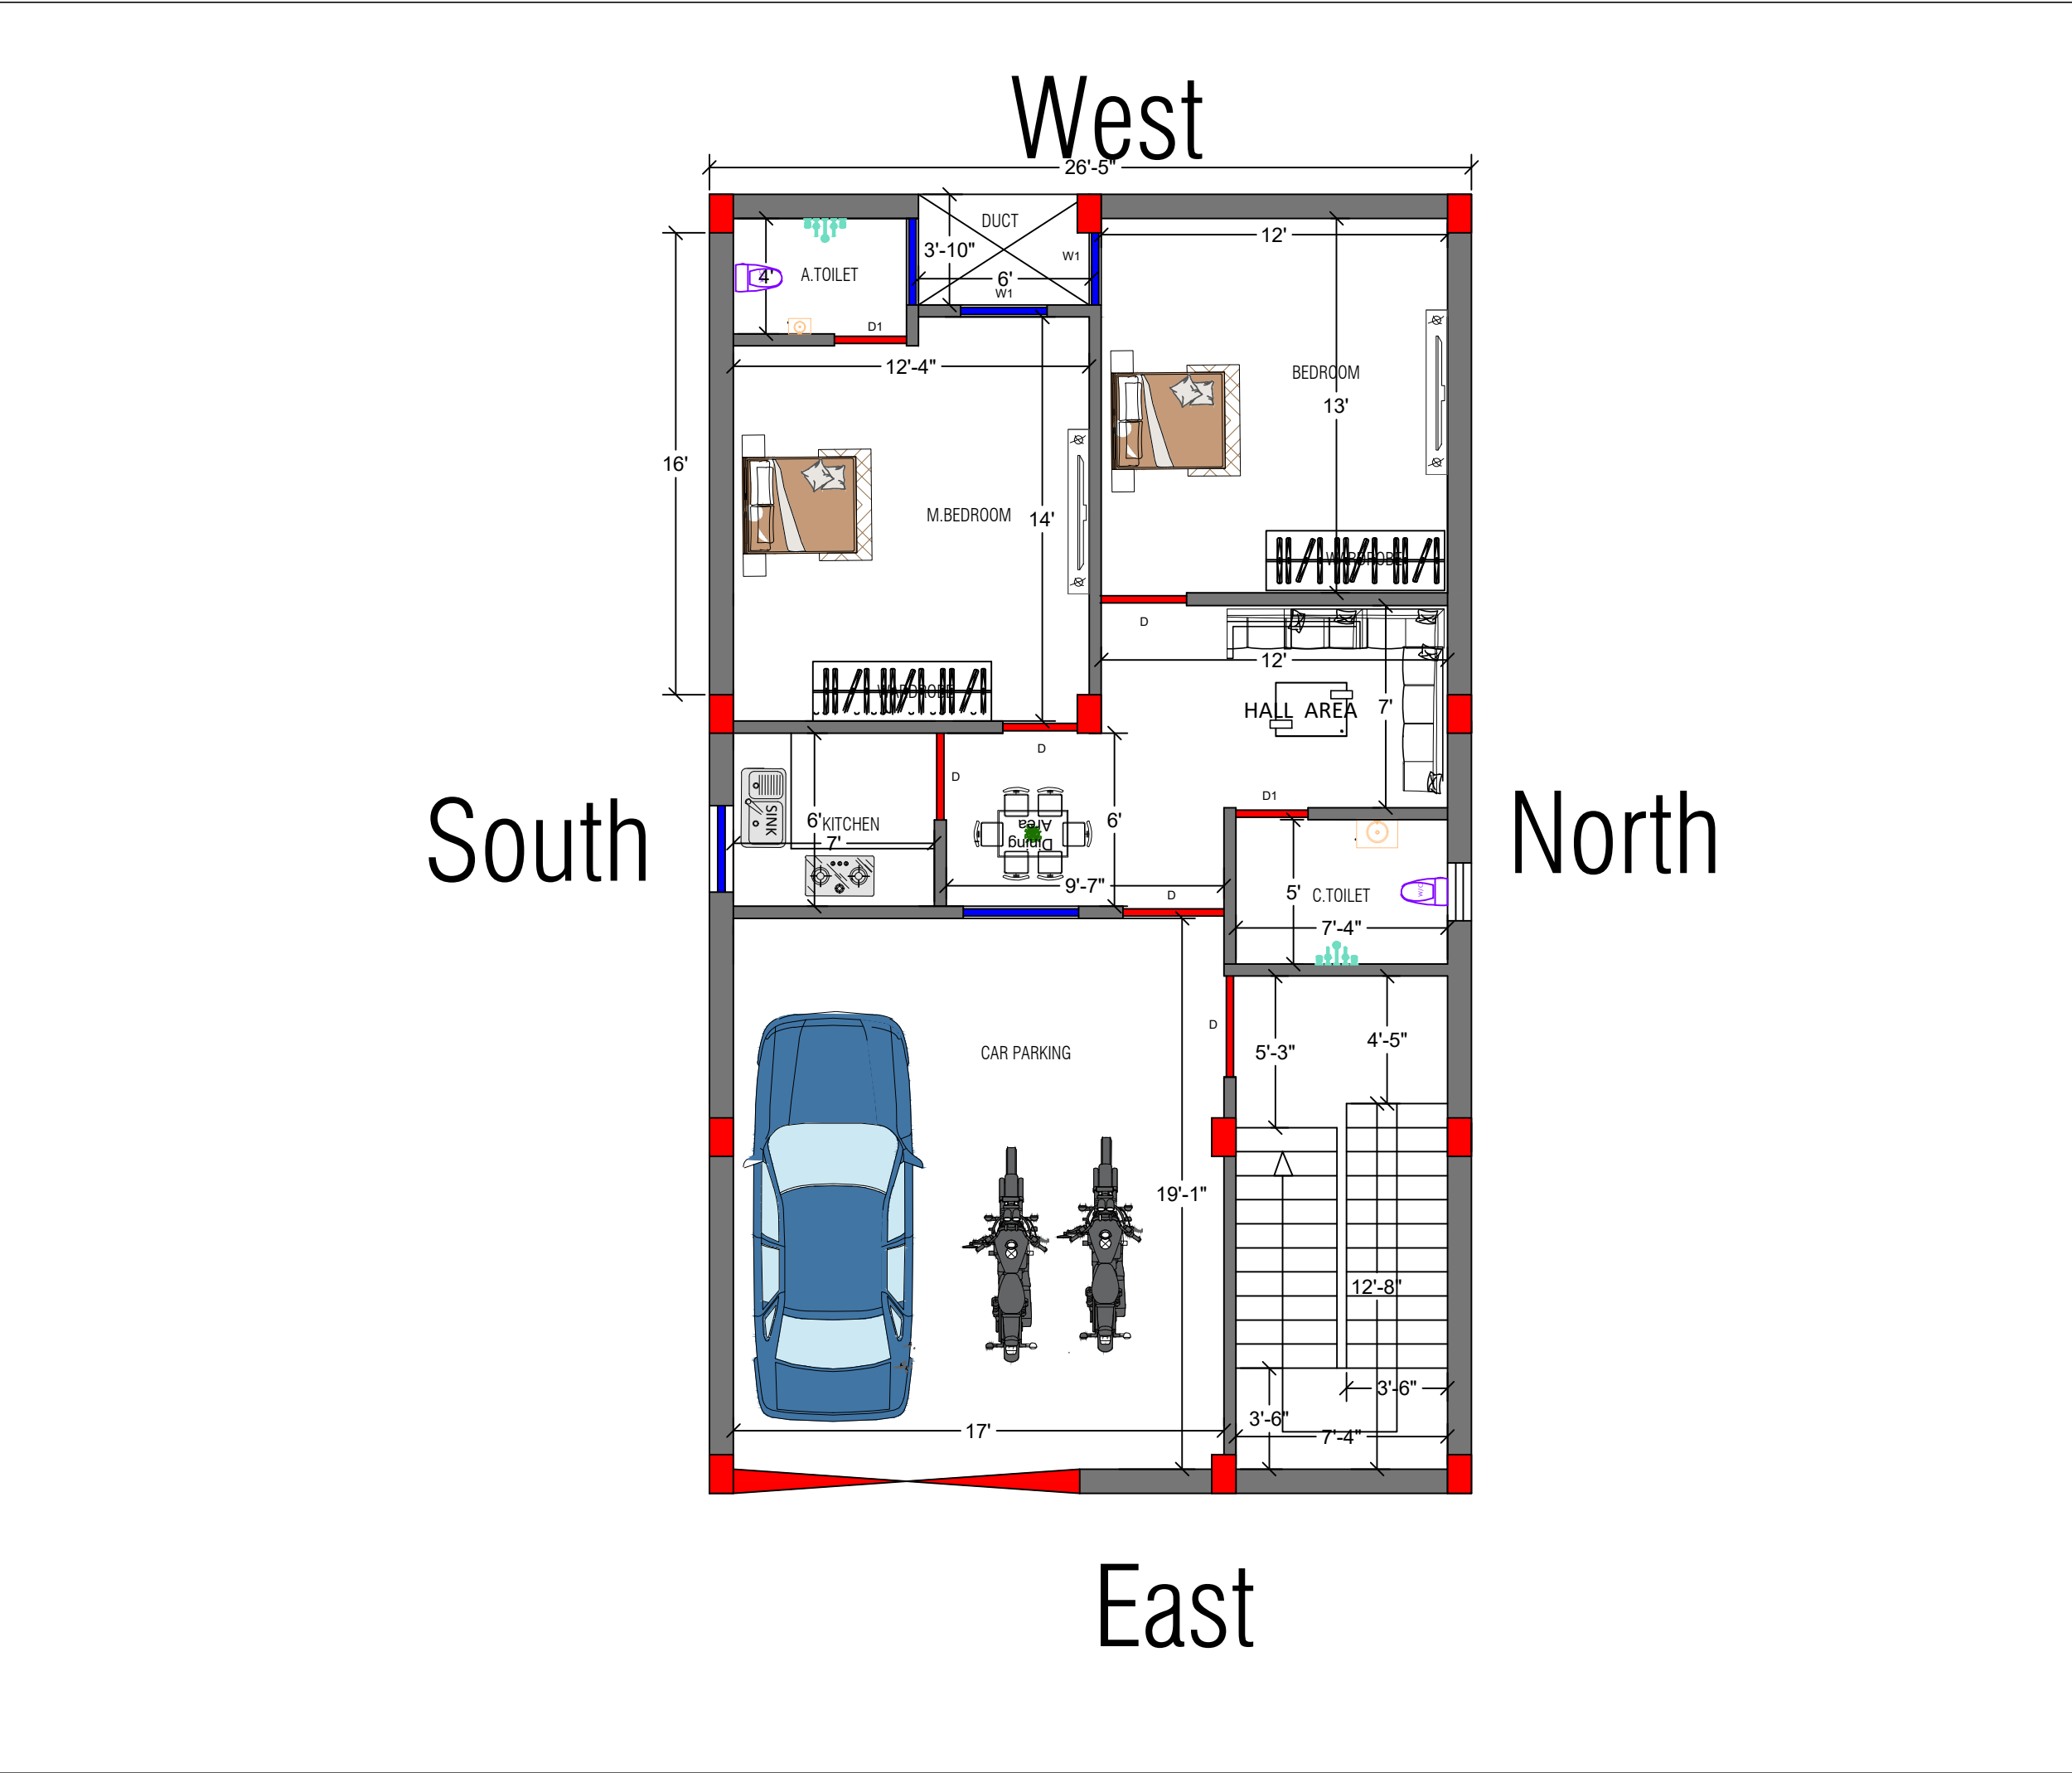

JAYPRO INFRATECH PVT.LTD.

Our Services

Architecture Design  
Structure Design  
Interior Design  
Estimating & Costing  
Building Construction With Material

Outer Wall- 10"  
Inner Wall- 05"

SCHEDULE OF DOOR & WINDOWS

| SP. | L      | B | H      | SILL H. |
|-----|--------|---|--------|---------|
| D   | 3'-00" | - | 7'-00" | 3'-00"  |
| D1  | 2'-06" | - | 7'-00" | 3'-00"  |
|     |        |   |        |         |
| W   | 4'-00" | - | 4'-00" | 3'-00"  |
| W1  | 3'-00" | - | 4'-00" | 4'-00"  |
|     |        |   |        |         |
| V   | 2'-00" | - | 1'-06" | 8'-06"  |
|     |        |   |        |         |

Details Of Stair:-  
Celling Height :- 10'  
Height Of Riser:- 6  
Width Of Trade :- 10"  
Width Of Stair :- 3'-6"  
Width Of Landing :- 3'-6"  
Steps Of Stair :- 21

E

THIS DRAWING HAS NOT BEEN PUBLISHED AND IS THE SOLE PROPERTY OF  
PURPOSE AS STATED IN THE AGREEMENT AND IT SHALL NOT BE REPRODUCED,  
COPIED, LENT OR OTHERWISE DISPOSED OF DIRECTLY OR INDIRECTLY, NOR USED  
FOR ANY OTHER PURPOSE OTHER THAN FOR WHICH IT IS FURNISHED.  
ALL DIMENSIONS ARE IN MILLIMETER UNLESS OTHERWISE SPECIFIED.

CLIENT :-

MR.SUBODH KUMAR (CHIRAURA,AIIMS)


PROJECT :-

GROUND FLOOR PLAN

|               |                           |        |         |
|---------------|---------------------------|--------|---------|
| SCALE:-       | 1:100                     | ISSUED | 22.8.25 |
| Plan Number:- | 01                        |        |         |
| Design By     | Ar. Soni Kumari           |        |         |
| Checked By    | Er. Jayprakash Kumar      |        |         |
| Approved By   | Jaypro Infratech Pvt.Ltd. |        |         |


Jaypro Infratech Pvt.Ltd.

Office Address: 1st Floor, Pandooi  
Place, Boring Road, Patna- 80001

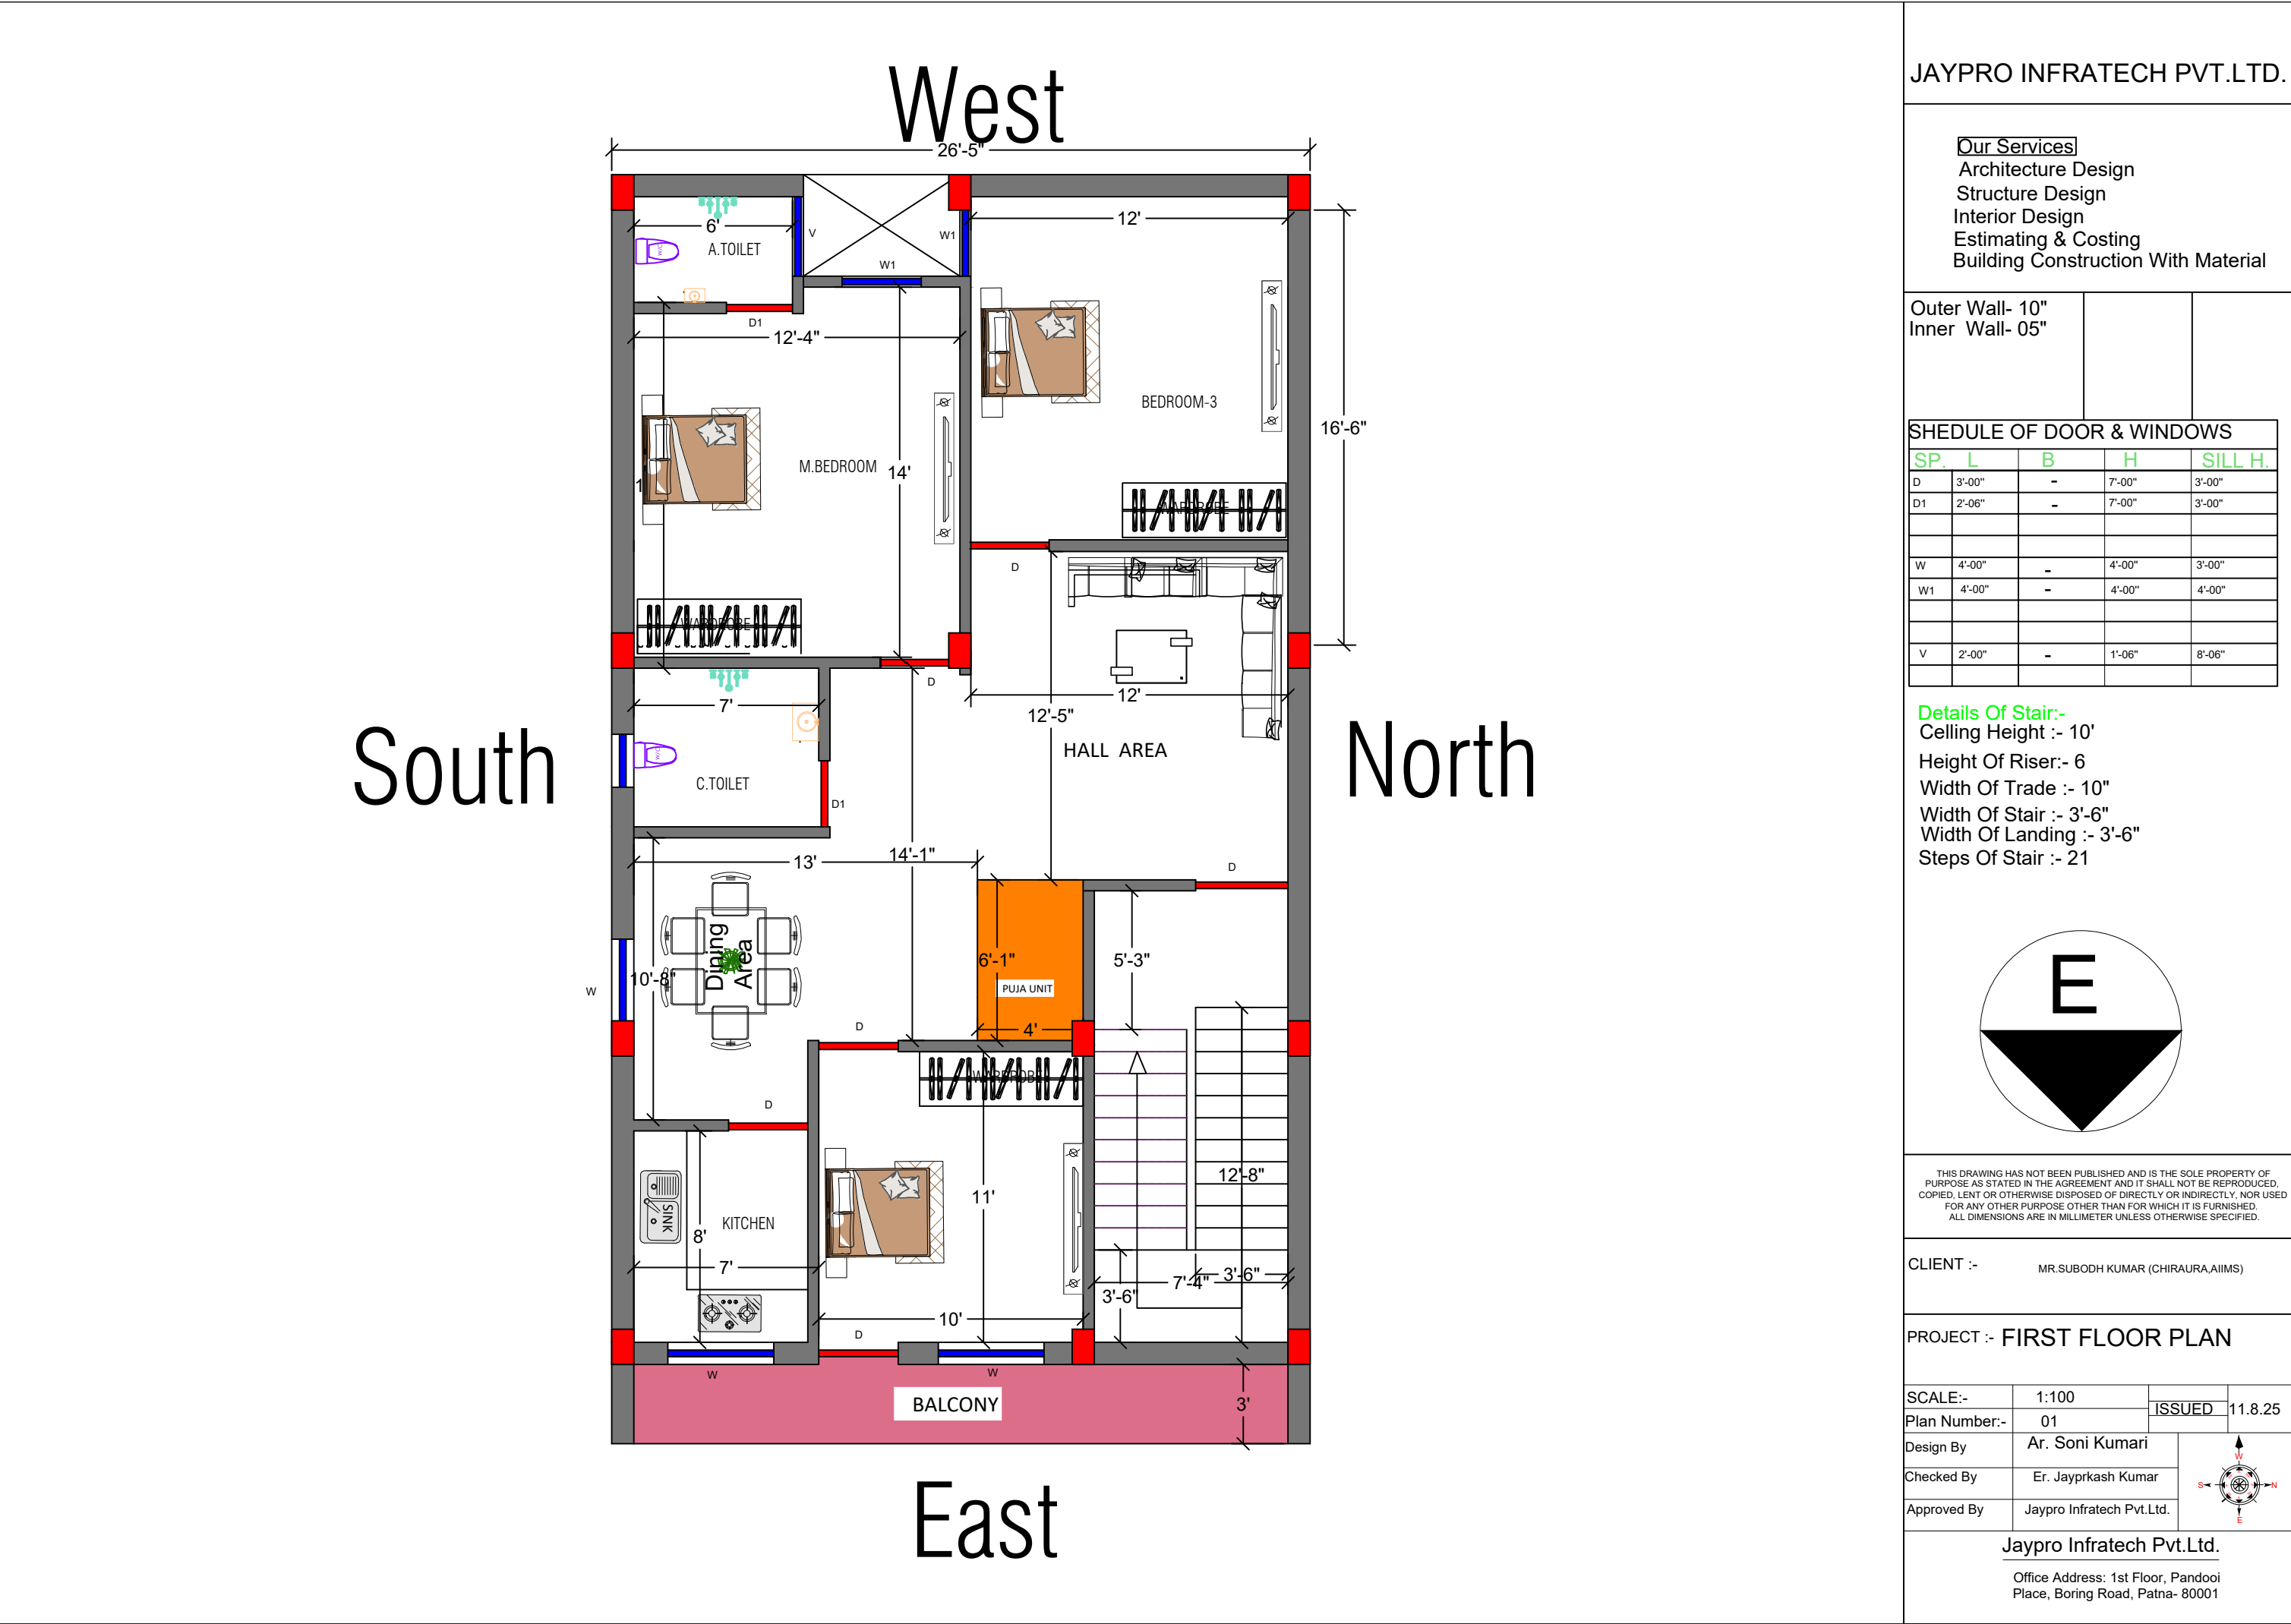

### Our Services


- Architecture Design
- Structure Design
- Interior Design
- Estimating & Costing
- Building Construction With Material

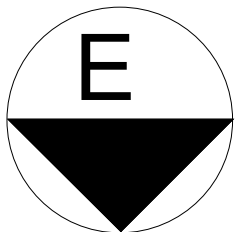


CLIENT :- MR.SUBODH KUMAR (CHIRAURA,AIIMS)


|               |       |        |          |
|---------------|-------|--------|----------|
| SCALE:-       | 1:100 |        | 24.07.25 |
| Plan Number:- | 01    | ISSUED |          |

|             |                           |
|-------------|---------------------------|
| Approved By | Jaypro Infratech Pvt.Ltd. |
|-------------|---------------------------|

 

 

Office Address: 1st Floor, Pandooi  
Place, Boring Road, Patna- 80001



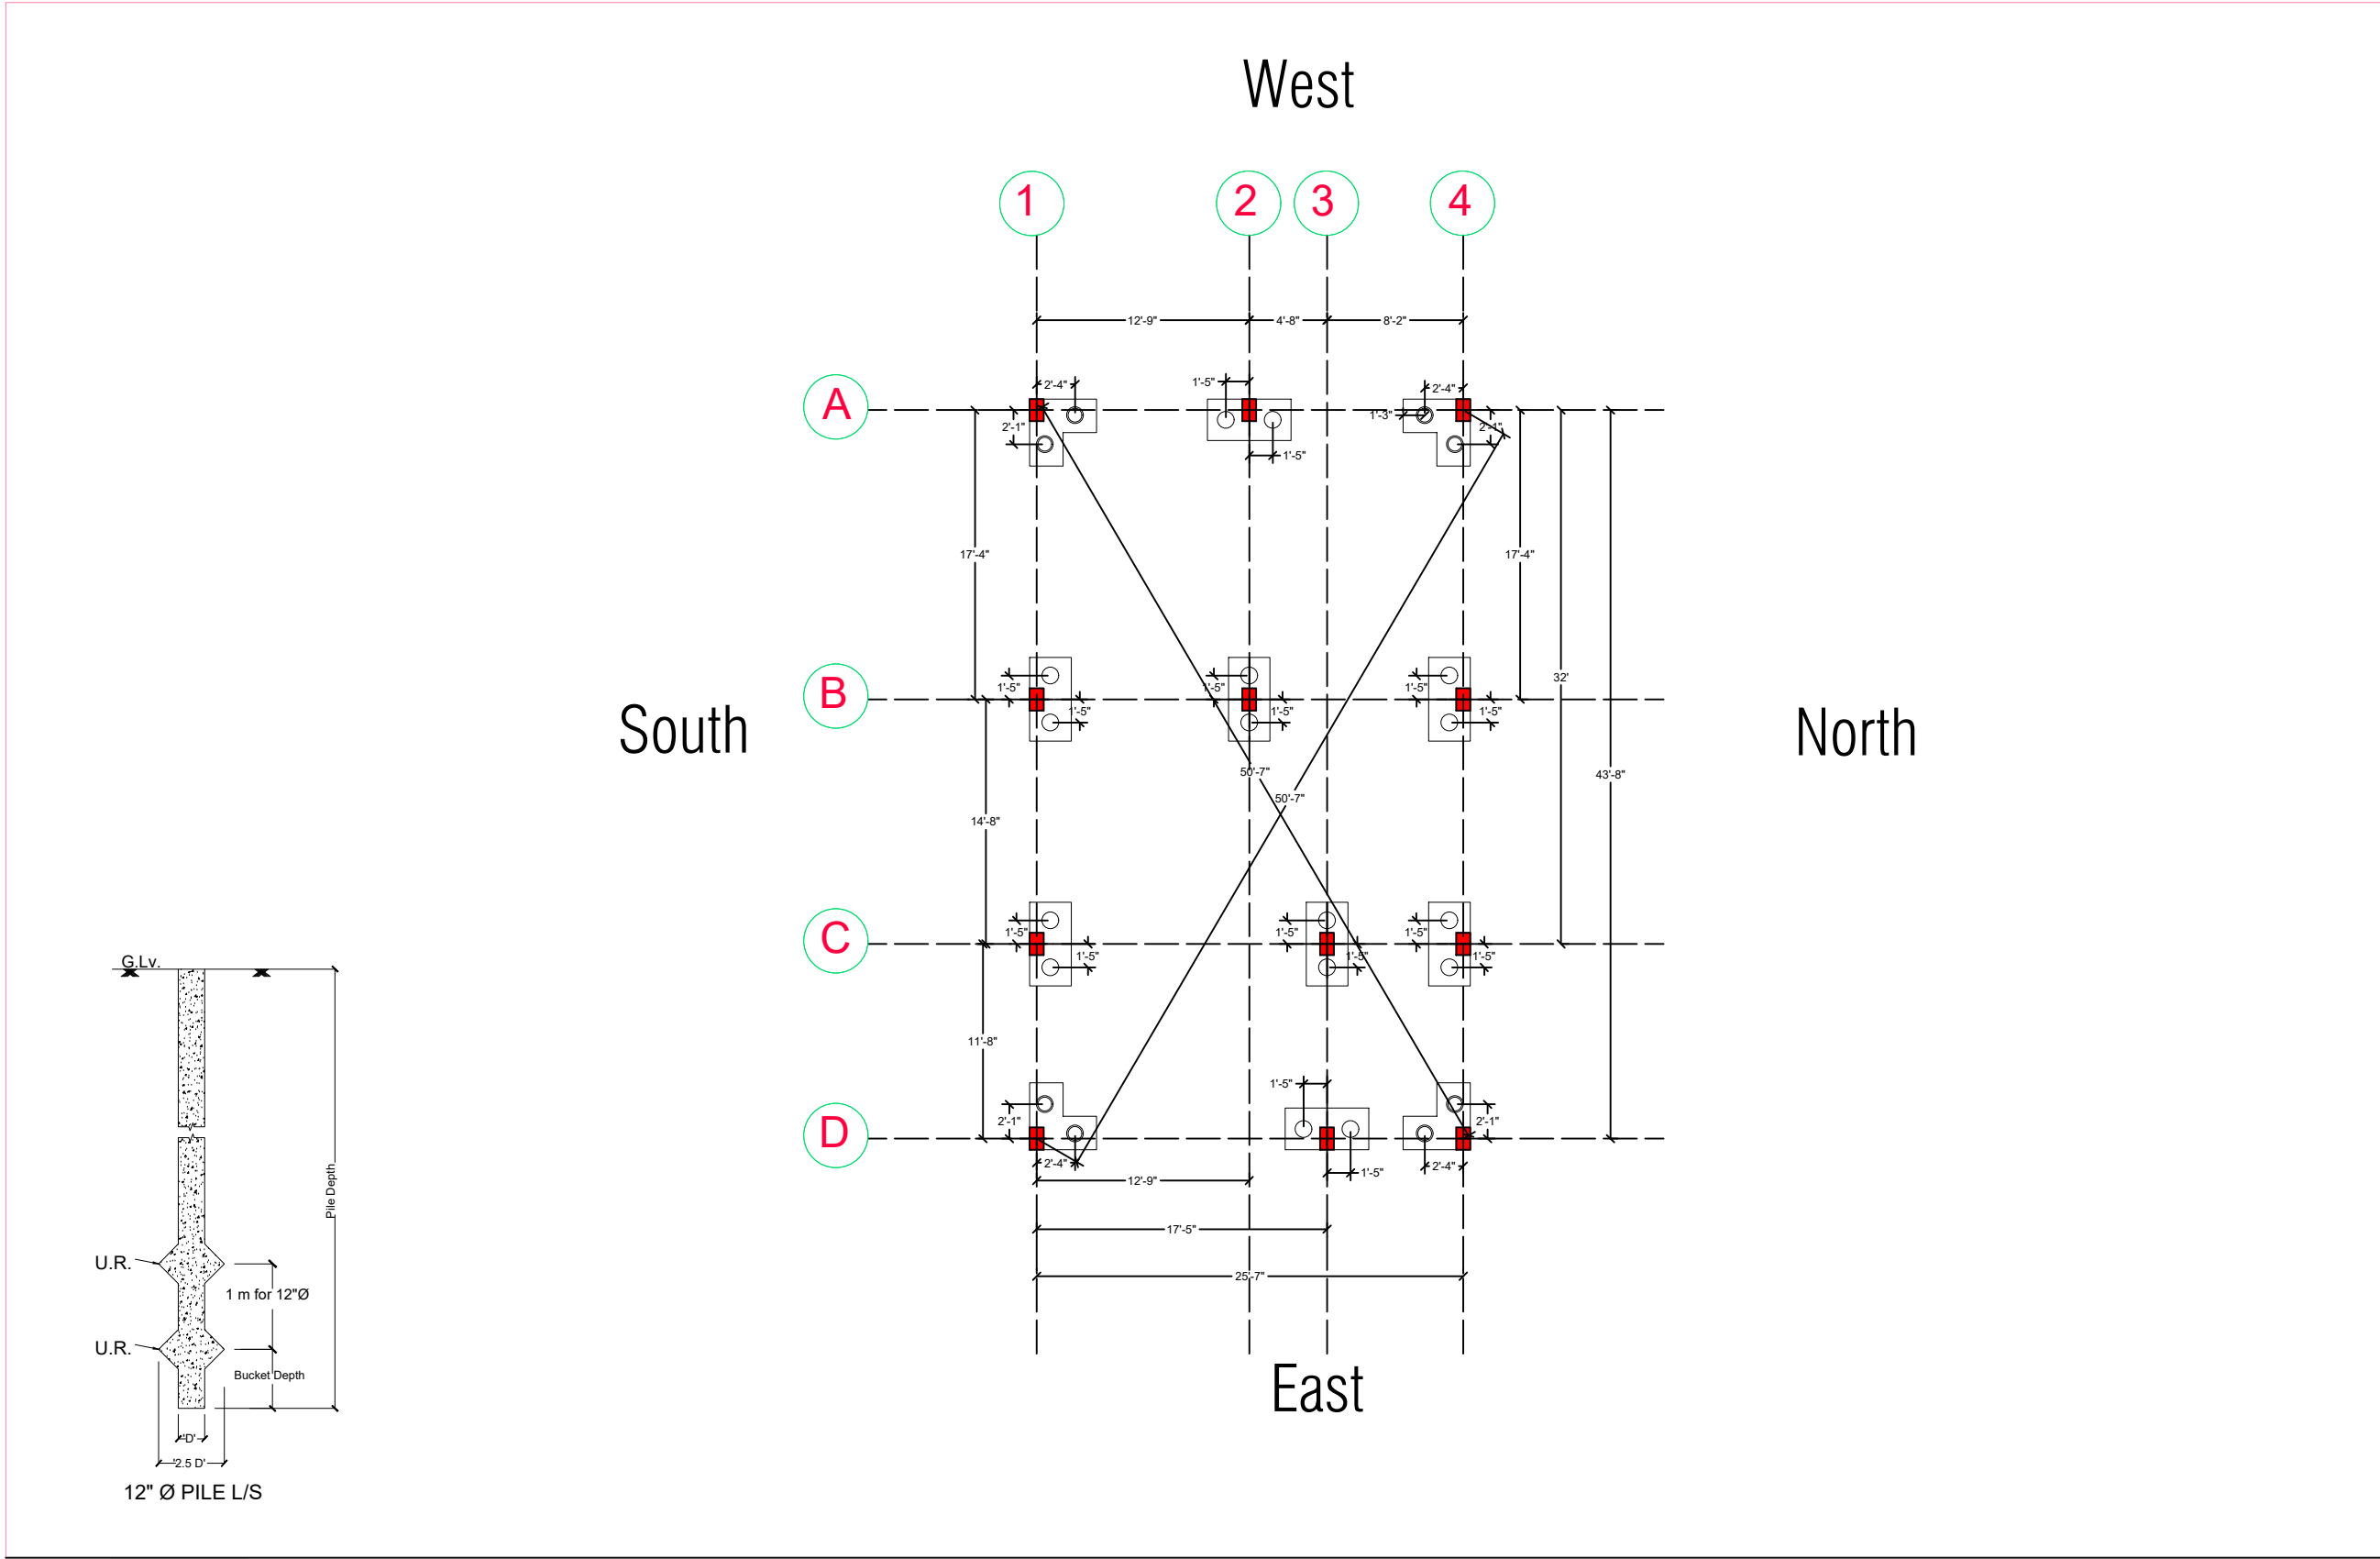


- TECHNICAL NOTES & INSTRUCTIONS:-
- NOTES AND INSTRUCTIONS INDICATED BELOW SHALL BE FOLLOWED WITH DUE RESPONSIBILITY BY ENGINEER IN-CHARGE DURING EXECUTION OF THE PROJECT.
  - THE ENGINEER IN-CHARGE SHALL STUDY IN-DEPTH THE ARCHITECTURAL/STRUCTURAL DRAWINGS OF THE BUILDING / STRUCTURE ENCLOSED, BEFORE EXECUTION AND AMBIGUITY IF ANY NOTICED BY HIM SHALL BE REPORTED TO CONSULTANT FOR NECESSARY ACTION. ALL DIMENSIONS ARE IN MM FOLLOW WRITTEN DIMENSION ONLY.
  - ONLY STEEL SHUTTERING / CENTERING SHALL BE USED AT WORK SITE FOR CONSTRUCTION OF R.C.C. FRAMED BUILDING.
  - QUALITY AND MIX PROPORTION OF MATERIALS TO BE USED IN CONCRETING I.E. WATER / CEMENT / SAND / CHIPS SHALL BE STRICTLY AS PER DESIGN MIX REPORT.
  - THE CRUSHING STRENGTH OF CUBES PREPARED WITH CONC. MIX AT WORK SITE SHALL CONFORM THE ACCEPTANCE CRITERIA AS MENTIONED IN I.S. 456: 2000.
  - COVER BLOCK WITH PROPER SIZE & SPECIFIED STRENGTH SHALL BE PROVIDED IN SLAB / BEAM / COLUMN / FOUNDATION BEFORE R.C.C. CASTING @ SPACE NOT EXCEEDING ONE METER C/C.
  - COVER BLOCK SHALL BE PROPERLY TIED WITH THE REINFORCEMENT FOR FIXITY DURING ACTUAL SITE CONDITION.
  - IN CASE OF PILE FOUNDATION IT IS ESSENTIAL TO HAVE ACTUAL PILE LOAD TEST REPORT ALONG WITH PILE CAPACITY BASED ON SOIL PARAMETERS. SO IT IS INSTRUCTED TO GET THE ACTUAL PILE LOAD TEST REPORT BEFORE EXECUTION AND REPORT TO CONSULTANT FOR REVIEW AND FINAL CONCLUSION.
  - IN CASE OF PILE FOUNDATION HAVING HIGH WATER TABLE USE BENTONITE SOLUTION, CASING AND QUICK SETTING CEMENT. THE ENGINEER IN-CHARGE SHALL TAKE FINAL DECISION AS PER ACTUAL SITE CONDITION.
  - ALL CONCRETE SHALL BE MACHINE MIXED AND PROPERLY COMPACTED BY VIBRATOR.
  - NOMINAL COVER I.E. CLEAR CONCRETE COVER TO ALL REINFORCEMENTS INCLUDING LINGS FOR FOUNDATION = 50, PILE CAP = 75, COLUMN = 40, BEAM = 30 AND SLAB = 25mm SHALL BE PROVIDED.
  - PROPER CURING OF R.C.C. SLAB / COLUMN / FOUNDATION / BW PLASTER ETC. SHALL BE ENSURED BY FIELD ENGRS.
  - PROPER ARRANGEMENT FOR SOAKING OF BRICKS SHALL BE ENSURED BY FIELD ENGRS.
  - BEFORE PLACING OF REINFORCEMENT POLYTHENE SHEET SHALL BE SPREAD OVER SHUTTERING TO PREVENT CEMENT SLURRY FROM CONC. MIX.
  - BEFORE CASTING REINFORCEMENT PLACED SHALL BE EXACTLY MEASURED BY ENGR INCHARGE.
  - LDH EFFECTIVE DEVELOP. LENGTH CONSIDERING TENSION 48X BAR DIA.
  - LDH + EFFECTIVE DEVELOP. LENGTH CONSIDERING COMPRESSION 38X BAR DIA.
  - LAP SPlice: NOT MORE THAN 50% OF AREA OF STEEL (LONG) IN COLUMN BARS SHALL BE SPliced AT ANY ONE SECTION. LAPPING OR WELDING OF IT SHALL BE STAGGERED.
  - IT SHALL BE WITHIN THE LAPPING ZONE AS SHOWN IN THE DRG. THE LAP LENGTH SHALL NOT BE LESS THAN DEVELOPMENT LENGTH OF ROD AND 30 TIMES DIA OF BAR WHICH IS GREATER.
  - LAP SPlice IN BEAM SPAN LESS THAN 12M SHALL BE AVOIDED IN NORMAL CASE. IN LONGER SPAN (L > 12M) LAP SHALL BE PROVIDED AS PER APPROVED STR. DRG.
  - ONLY WRITTEN DIMENSIONS ARE TO BE FOLLOWED.
  - GRID LINE SHOWS CL OF WALLS.
  - THE FORM WORK FOR (SPAN < 4M) BEAMS & SLAB SHALL BE SO ASSEMBLED AS TO PROVIDE CAMBER AS FOLLOWS:-
  - CAMBER FOR NORMAL BEAMS SHALL BE 1 IN 250 OF THE SPAN OR 4MM PER METER OF SPAN AT THE CENTRAL POINT.
  - FOR CANTILEVER BEAMS SLAB CAMBER AT THE FREE END SHALL BE SPAN / 50 OF THE PROJECTED LENGTH.
  - REMOVAL OF FORM WORK SHALL BE AS PER STRIPPING TIME PRESCRIBED VIDE CL. 11.3 OF I.S. 456:2000 WHICH SHALL BE CHECKED BY E.E./A.E.
  - IN FRAME STRUCTURE ALL EXTERNAL STAIR WALL SHALL BE 10" THICK AND INTERNAL WALL SHALL BE 8" THICK EXCEPT MENTIONED.
  - NECESSARY ARRANGEMENTS SHALL BE MADE FOR PLINTH PROTECTION OF BUILDING AT LEVEL DECIDED BY E.E. TO AVOID WATER LOGGING AROUND BUILDING THE WIDTH SHALL BE DECIDED AS PER ACTUAL SITE CONDITION BY ENGINEER IN-CHARGE.
  - FLOOR SLAB TO PREVENT SEEPAGE ALL DESIGN MIX CONCRETE OF GRADE M 25 HAVING MINIMUM CEMENT CONTENT 300 kg/m<sup>3</sup> Max. W/C = 0.5 FOR COARSE AGGREGATE 20 mm SIZE CASTING SHOULD BE DONE AS PER MIX DESIGN.
- # OR T INDICATES HYSD BARS OF GRADE Fe 500  
THIS DRAWING SHALL BE READ WITH THE APPROVED ARCHITECTURAL DRAWINGS.

- NOTES:-
- ALL CONCRETE MIX M:25 UNLESS OTHERWISE SPECIFIED.
  - ALL TOR STEEL YIELD STRENGTH 500 N/mm<sup>2</sup>.
  - CLEAR COVER TO MAIN STEEL 50 MM IN PILES, 40mm IN COLUMN.
  - DEPTH OF PILES SHALL BE MEASURED FROM CUT OFF LV / EXISTING G.L. WHICH EVER IS LOWER.
  - CUT - OFF LV. OF ALL PILES SHALL BE AT BOTTOM OF PILE CAP ITSELF.
  - PILE SHALL BE CASTED 300 ABOVE CUT OFF LV. BECHIPPED OFF UPTO CUT OFF LV.
  - 500 MM LENGTH OF MAIN BAR FROM PILE EXTEND BEYOND CUT OFF LV. TO BE EMBEDDED INTO PILE CAPS.
  - CENTRE OF PILE GROUP SHALL MATCH WITH CENTER OF COLUMN.

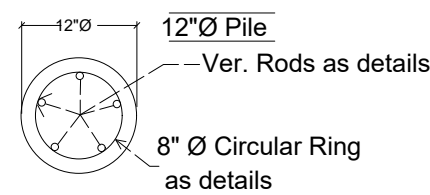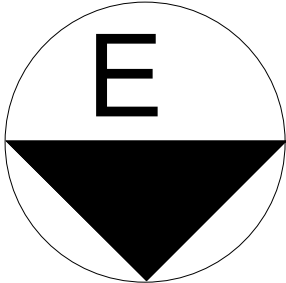

TYPICAL PILE C/S

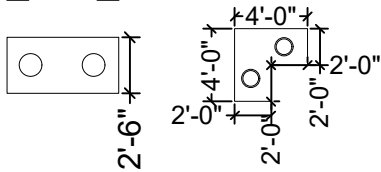

PC1

PC2

## PILE DETAILS

| Pile | DIA | DEPTH | DIA OF UR | UR | STEEL     | RINGS          | No. of Piles |
|------|-----|-------|-----------|----|-----------|----------------|--------------|
|      | 12" | 6M    | 30"       | 2  | 5- T12 mm | T8 mm @ 8" c/c | 24           |

## PILE CAP DETAILS

| Pile Cap | Pile Dia | Pile Cap Size | Pile Cap Depth (inch) | (Bottom Layer Mat)               |                                   | (Top Layer Mat-Inverted)         |                                   | Pile Group         |
|----------|----------|---------------|-----------------------|----------------------------------|-----------------------------------|----------------------------------|-----------------------------------|--------------------|
|          |          |               |                       | Main Steel ( b ' ) (Lower Level) | Dist. Steel ( t ' ) (Upper Level) | Main Steel ( b ' ) (Upper Level) | Dist. Steel ( t ' ) (Lower Level) |                    |
| Pc-1     | 12"      | 5'x2'-6"      | 18"                   | T10 @ 6" c/c                     | T10 @ 6" c/c                      | T10 @ 6" c/c                     | T10 @ 6" c/c                      | 8- 12" Ø Pile Grp. |
| Pc-2     | 12"      | 4'x2'         | 18"                   | T10 @ 6" c/c                     | T10 @ 6" c/c                      | T10 @ 6" c/c                     | T10 @ 6" c/c                      | 4- 12" Ø Pile Grp. |
|          |          |               |                       |                                  |                                   |                                  |                                   |                    |

THIS DRAWING HAS NOT BEEN PUBLISHED AND IS THE SOLE PROPERTY OF PURPOSE AS STATED IN THE AGREEMENT AND IT SHALL NOT BE REPRODUCED, COPIED, LENT OR OTHERWISE DISPOSED OF DIRECTLY OR INDIRECTLY, NOR USED FOR ANY OTHER PURPOSE OTHER THAN FOR WHICH IT IS FURNISHED. ALL DIMENSIONS ARE IN MILLIMETER UNLESS OTHERWISE SPECIFIED.

CLIENT : - MR. SUBODH KUMAR (CHIRAIKURA, AIMS)

## Design : - PILE & PILE CAP DETAILS


|               |       |            |
|---------------|-------|------------|
| SCALE : 1:100 | Issue | 29.08.2025 |
| Plan Number   | 01    |            |

|             |                            |  |
|-------------|----------------------------|--|
| Design By   | Ar. Soni Kumari            |  |
| Checked By  | Er. Jayprakash kumar       |  |
| Approved By | Jaypro infratech Pvt. Ltd. |  |

JAYPRO INFRA TECH PVT. LTD.  
Office Address: 1st Floor, Pandooi Place, Boring Road, Patna- 80001

Follow Now  
Insta Id: jaypro\_infratech  
Facebook Page: jaypro\_infratech

E-mail id: info@jayproinfratech.com, www.jayproinfratech.com, Call Now: 9835852462, 7277008312,

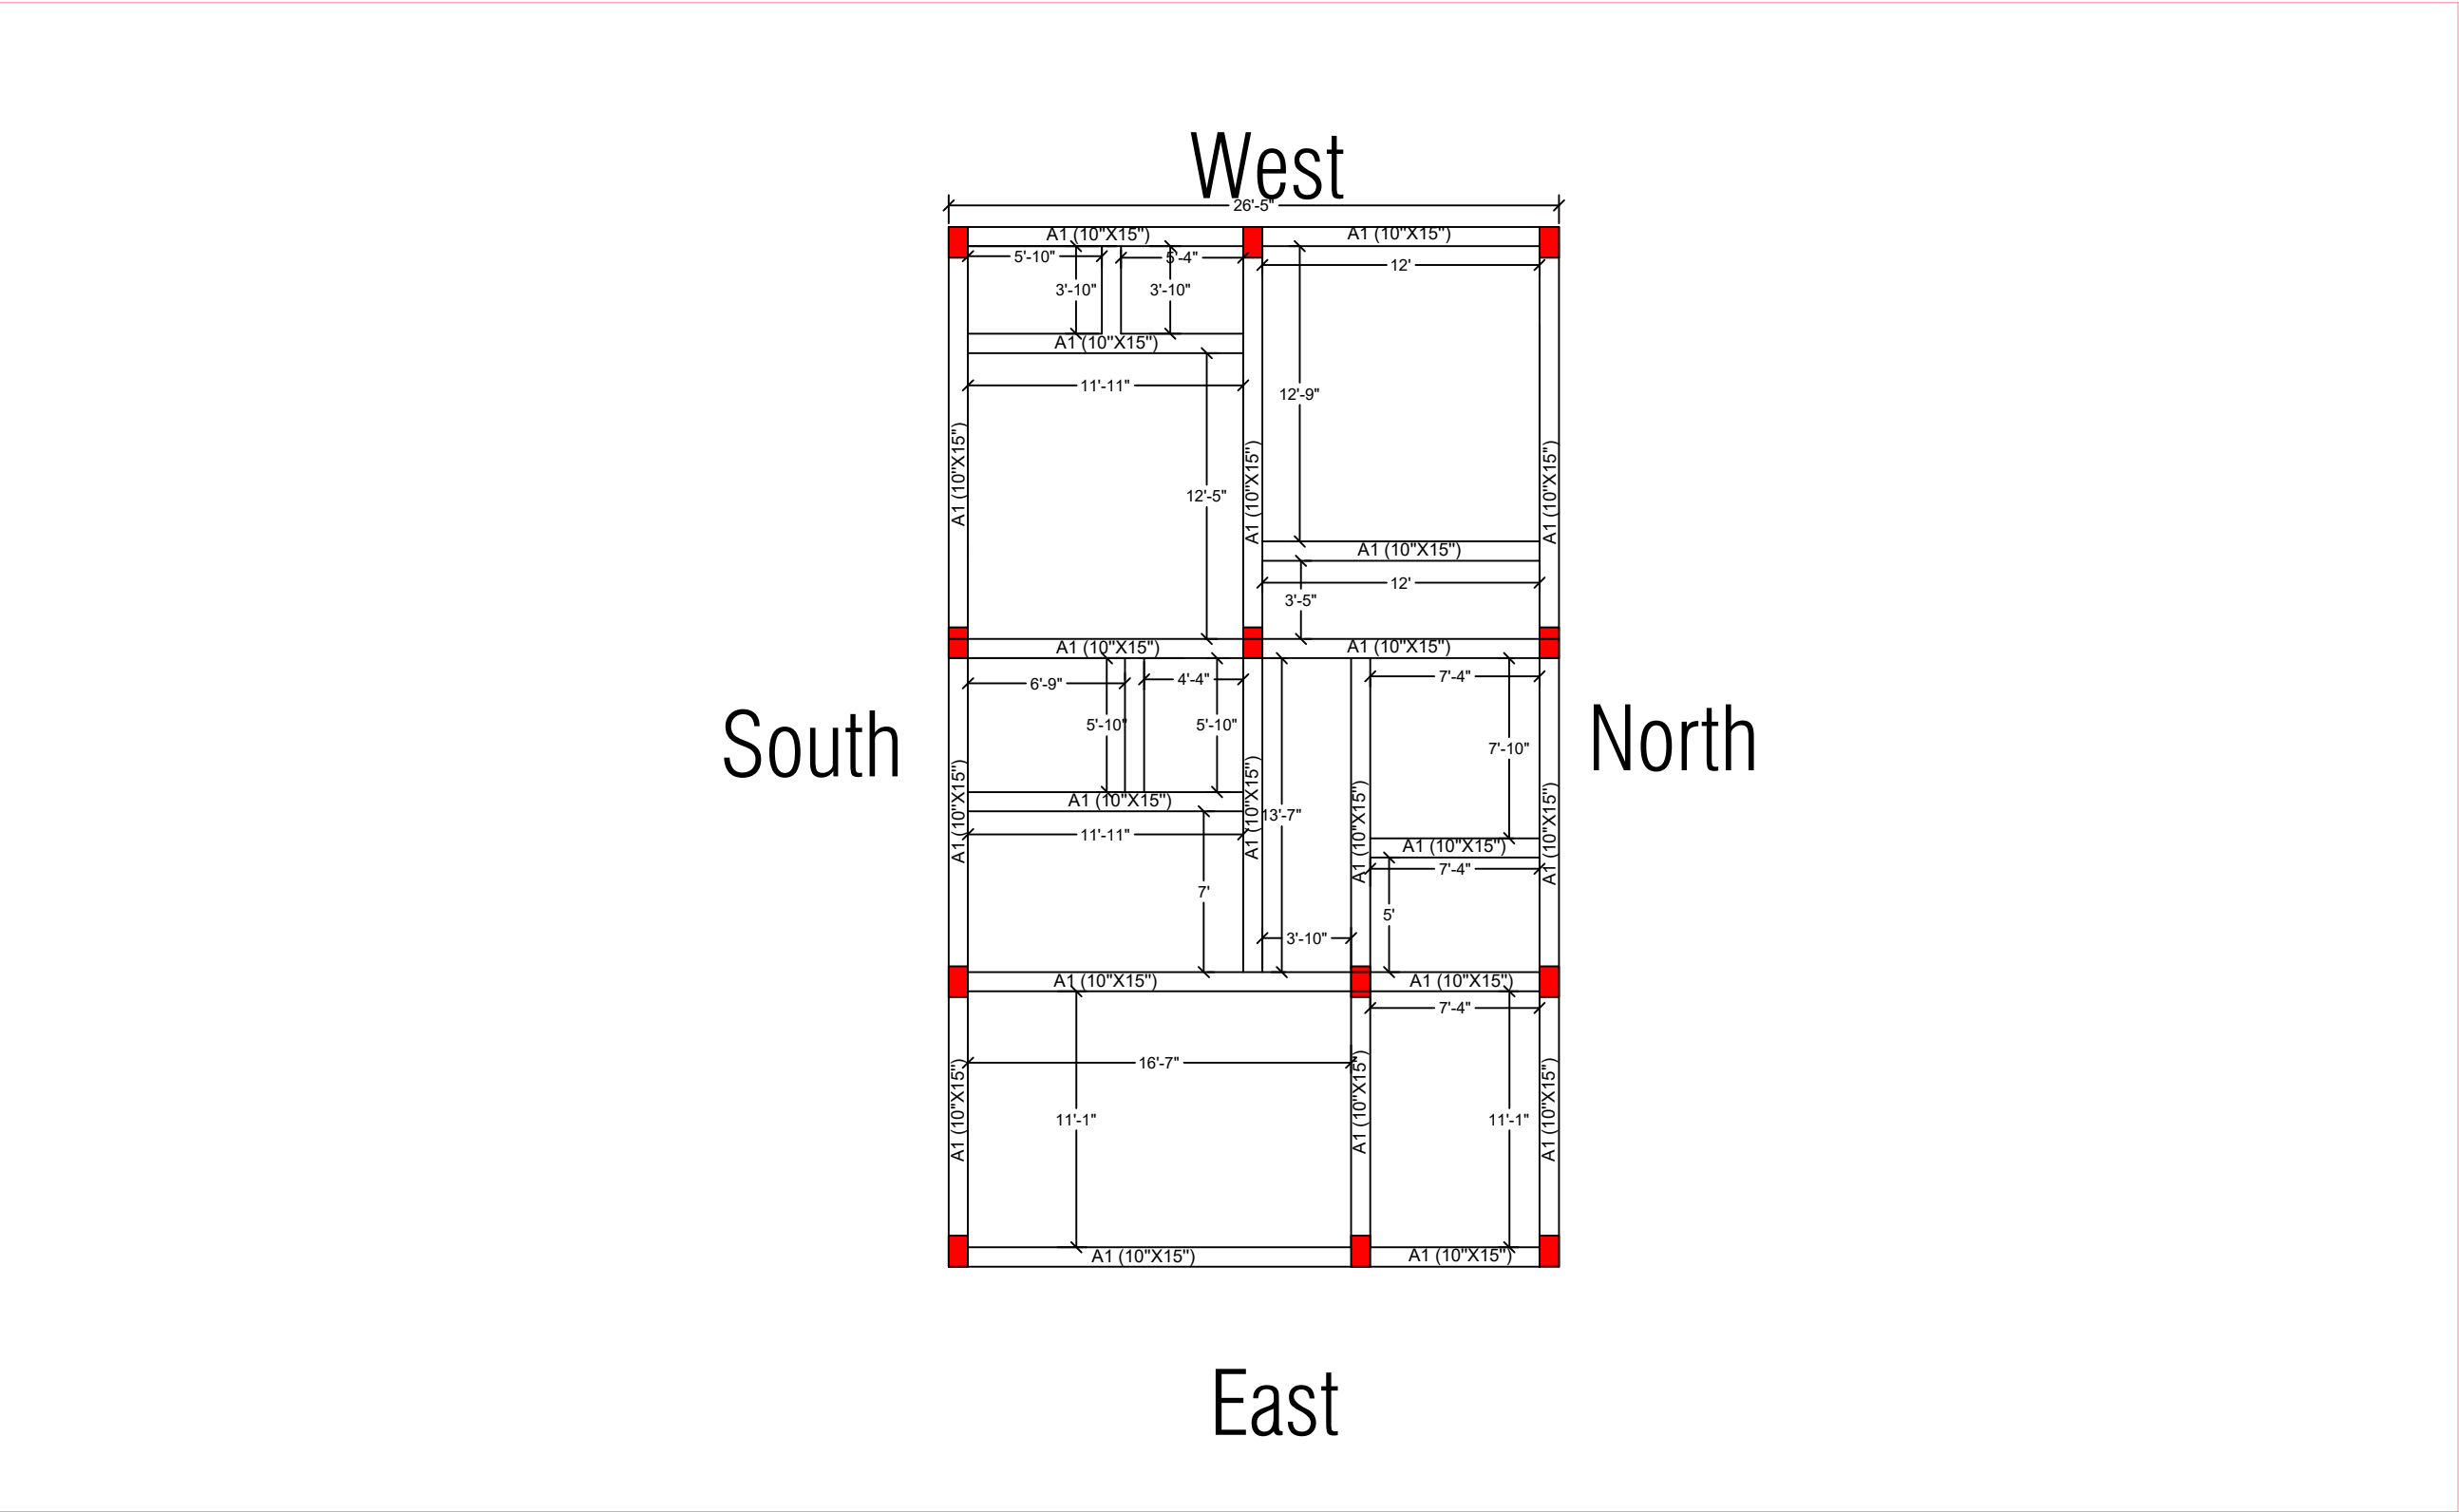

**TECHNICAL NOTES & INSTRUCTIONS:-**

1) NOTES AND INSTRUCTIONS INDICATED BELOW SHALL BE FOLLOWED WITH DUE RESPONSIBILITY BY ENGINEER IN-CHARGE DURING EXECUTION OF THE PROJECT.

2) THE ENGINEER IN-CHARGE SHALL STUDY IN-DEPTH THE ARCHITECTURAL/STRUCTURAL DRAWINGS OF THE BUILDING / STRUCTURE ENCLOSED, BEFORE EXECUTION AND AMBIGUITY IF ANY NOTICED BY HIM SHALL BE REPORTED TO CONSULTANT FOR NECESSARY ACTION.

ALL DIMENSIONS ARE IN MM.FOLLOW WRITTEN DIMENSION ONLY.

4) ONLY STEEL SHUTTERING / CENTERING SHALL BE USED AT WORK SITE FOR CONSTRUCTION OF R.C.C. FRAMED BUILDING.

5) QUALITY AND MIX PROPORTION OF MATERIALS TO BE USED IN CONCRETING I.E. WATER / CEMENT / SAND / CHIPS SHALL BE STRICTLY AS PER DESIGN MIX REPORT.

6) THE CRUSHING STRENGTH OF CUBES PREPARED WITH CONC. MIX AT WORK SITE SHALL CONFORM THE ACCEPTANCE CRITERIA AS MENTIONED IN IS : 456 : 2000.

7) COVER BLOCK WITH PROPER SIZE & SPECIFIED STRENGTH SHALL BE PROVIDED IN SLAB / BEAM / COLUMN / FOUNDATION BEFORE R.C.C. CASTING @ SPACE NOT EXCEEDING ONE METER C/C.

8) COVER BLOCK SHALL BE PROPERLY TIED WITH THE REINFORCEMENT FOR FIXITY DURING R.C.C. FRAMED BUILDING.

9) IN CASE OF PILE FOUNDATION IT IS ESSENTIAL TO HAVE ACTUAL PILE LOAD TEST REPORT ALONG WITH PILE CAPACITY BASED ON SOIL PARAMETERS. SO IT IS INSTRUCTED TO GET THE ACTUAL PILE LOAD TEST REPORT BEFORE EXECUTION AND REPORT TO CONSULTANT FOR REVIEW AND FINAL CONCLUSION.

10) IN CASE OF PILE FOUNDATION HAVING HIGH WATER TABLE USE BENTONITE SOLUTION, CASING AND QUICK SETTING CEMENT. THE ENGINEER IN -CHARGE SHALL TAKE FINAL DECISION AS PER ACTUAL SITE CONDITION.

11) ALL CONCRETE SHALL BE MACHINE MIXED AND PROPERLY COMPACTED BY VIBRATOR.

12) NOMINAL COVER (I.E. CLEAR CONCRETE COVER TO ALL REINFORCEMENTS INCLUDING LINKS) FOR FOUNDATION = 50, PILE CAP = 75, COLUMN = 40, BEAM = 30 AND SLAB = 25mm. SHALL BE PROVIDED.

13) PROPER CURING OF R.C.C. SLAB / COLUMN / FOUNDATION / B/W PLASTER ETC. SHALL BE ENSURED BY FIELD ENGRS.

14) PROPER ARRANGEMENT FOR SOAKING OF BRICKS SHALL BE ENSURED BY FIELD ENGRS.

15) BEFORE PLACING OF REINFORCEMENT POLYTHENE SHEET SHALL BE SPREAD OVER SHUTTERING TO PREVENT CEMENT SLURRY FROM CONC. MIX.

16) BEFORE CASTING REINFORCEMENT PLACED SHALL BE DULY MEASURED BY ENGR INCHARGE.

17) LDT+ EFFECTIVE DEVELOP. LENGTH CONSIDERING TENSION 48X BAR DIA.

18) LDC + EFFECTIVE DEVELOP. LENGTH CONSIDERING COMPRESSION 88X BAR DIA.

19A) LAP SPLICE- NOT MORE THAN 50% OF AREA OF STEEL (LONG) IN COLUMN BARS SHALL BE SPLICED AT ANY ONE SECTION. LAPING OR WELDING OF RT. SHALL BE STAGGERED.

IT SHALL BE WITHIN THE LAPPING ZONE AS SHOWN IN THE DRG. THE LAP LENGTH SHALL NOT BE LESS THEN DEVELOPMENT LENGTH OF 30 TIMES DIA OF BAR WHICH IS GREATER.

19B) LAP SPLICE IN BEAM SPAN LESS THAN 12M SHALL BE AVOIDED IN NORMAL CASE. IN LONGER SPAN (L > 12M) LAP SHALL BE PROVIDED AS PER APPROVED STR. DRG.

20) ONLY WRITTEN DIMENSIONS ARE TO BE FOLLOWED.

21) GRID LINE SHOWS CL OF WALLS.

22) THE FORM WORK FOR (SPAN+4M ) BEAMS & SLAB SHALL BE SO ASSEMBLED AS TO PROVIDE CAMBER AS FOLLOWS :-

a) CAMBER FOR NORMAL BEAMS SHALL BE 1 IN 250 OF THE SPAN OR 4MM PER METER OF SPAN AT THE CENTRAL POINT

b) FOR CANTILEVER BEAMS /SLAB CAMBER AT THE FREE END SHALL BE SPAN / 50 OF THE PROJECTED LENGTH

23) BEFORE R.C.C. CASTING OF BEAMS/SLAB FORM WORK SHALL BE CHECKED PROPERLY TO AVOID ANY DEFLECTION

24) REMOVAL OF FORM WORK SHALL BE AS PER STRIPPING TIME PRESCRIBED VIDE CL. 11.3 OF I.S. 456-2000 WHICH SHALL BE CHECKED BY E.E./J.E.

25) IN FRAME STRUCTURE ALL EXTERNAL & STAIR WALL SHALL BE 10"THICK AND INTERNAL WALL SHALL BE 9" THICK EXCEPT MENTIONED.

26) NECESSARY ARRANGEMENTS SHALL BE MADE FOR PLINTH PROTECTION OF BUILDING AT LEVEL DECIDED BY E.E. TO AVOID WATER LOGGING AROUND BUILDING THE WIDTH SHALL BE DECIDED AS PER ACTUAL SITE CONDITION BY ENGINEER IN-CHARGE.

27) WATER PROOFING COMPOUND SHALL BE USED IN CASTING OF SUNKEN SLAB & TERRACE FLOOR SLAB TO PREVENT SEEPAGE.

ALL DESIGN MIX CONCRETE OF GRADE M 25 HAVING MINIMUM CEMENT CONTENT 300 kg/m<sup>3</sup>. Max. W/C = 0.5 FOR COARSE AGGREGATE 20 mm SIZE CASTING SHOULD BE DONE AS PER MIX DESIGN

# OR T INDICATES HYSD BARS OF GRADE Fe 500D

THIS DRAWING SHALL BE READ WITH THE APPROVED ARCHITECTURAL DRAWINGS.

**NOTES:-2**

1. ALL DIMENSIONS ARE IN FEET AND INCHES

2. ALL CONCRETE MIX M-20 UNLESS OTHERWISE SPECIFIED

3. ALL TOR STEEL YIELD STRENGTH 500 N/mm<sup>2</sup>.

4. ALL CONCRETE SHALL BE MACHINE MIXED AND MACHINE VIBRATED.

5. CLEAR COVER TO MAIN STEEL 40 MM IN PILES, 20mm IN SLAB, 25mm IN BEAM, 40mm IN COLUMN.

6. ALL DIMENSIONS ARE TO BE READ NOT TO BE MEASURED.

7. ALL DIMENSIONS & DETAILS ARE TO BE VERIFIED WITH THE ARCHITECTURAL DRAWING AMBIGUITY IF ANY SHOULD BE BROUGHT TO THE NOTICE OF THE CONSULTING ENGINEERS.

8. WHEREVER SHOWN BEAM BAR SHALL BE ANCHORED INTO COLUMN UP-TO A LENGTH EQUAL TO 50X BAR DIA DISTANCE MEASURED FROM COLUMN FACE

9. BARS TO BE CUT & BENT NEAR OPENINGS/POCKETS.

THIS DRAWING HAS NOT BEEN PUBLISHED AND IS THE SOLE PROPERTY OF PURPOSE AS STATED IN THE AGREEMENT AND IT SHALL NOT BE REPRODUCED, COPIED, LENT OR OTHERWISE DISPOSED OF DIRECTLY OR INDIRECTLY, NOR USED FOR ANY OTHER PURPOSE OTHER THAN FOR WHICH IT IS FURNISHED. ALL DIMENSIONS ARE IN MILLIMETER UNLESS OTHERWISE SPECIFIED.

CLIENT :- MR.SUBODH KUMAR (CHIRAURA,AIMS)

PROJECT :- GROUND FLOOR TIE BEAM

SCALE: 1:100


Plan Number 01

DESIGNED BY: Ar. Sori Kumar




CHECKED BY: Er. Jayprakash kumar


APPROVED BY: Jaypro infratech Pvt. Ltd.

JAYPRO INFRATECH PVT. LTD.  
Office Address: 1st Floor, Pandooi Place, Boring Road, Patna- 80001


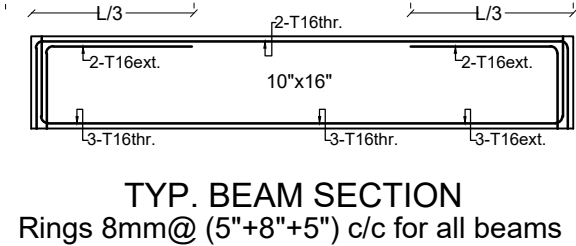


| BEAM REINFORCEMENT INDEX |      |     |               |              |             |              |          |          |
|--------------------------|------|-----|---------------|--------------|-------------|--------------|----------|----------|
| BEAM<br>MKD              | SIZE |     | REINFORCEMENT |              |             |              | STIRRUPS |          |
|                          |      |     | TOP REINF.    |              | BOT. REINF. |              |          |          |
|                          | B    | D   | TOP.M (t1)    | TOP.EXT (t2) | BOT.M (b1)  | BOT.EXT (b2) | S1       | S2       |
| A1                       | 10"  | 15" | 2-T16         | 2-T16        | 3-T16       | 3-T16        | T8@5"c/c | T8@5"c/c |

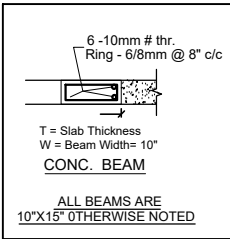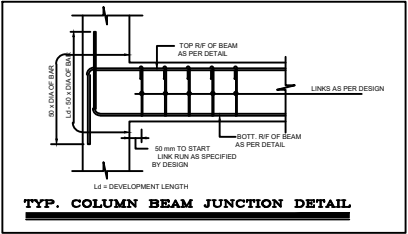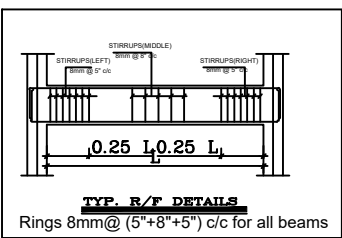



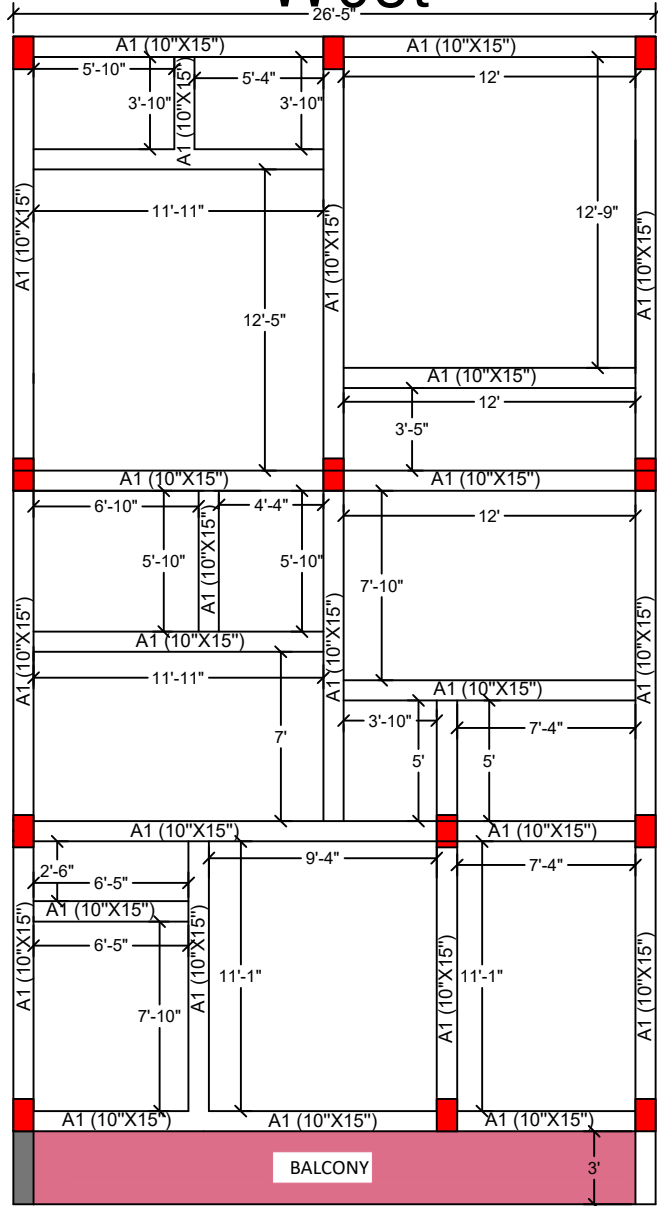
[illegible]

2. ALL DIMENSIONS ARE IN FEET AND INCHES
3. ALL CONCRETE MIX M-20 UNLESS OTHERWISE SPECIFIED
4. ALL TOR STEEL YIELD STRENGTH 500 N/mm<sup>2</sup>
5. ALL CONCRETE SHALL BE MACHINE MIXED AND MACHINE VIBRATED
6. CLEAR COVER TO MAIN STEEL  
40mm IN PILES, 20mm IN SLAB,  
25mm IN BEAM, 40mm IN COLUMN.
7. TO DIMENSIONS ARE TO BE READ NOT TO BE MEASURED
8. ALL DIMENSIONS & DETAILS ARE TO BE VERIFIED WITH THE ARCHITECTURAL DRAWING AMBIGUITY IF ANY SHOULD BE BROUGHT TO THE NOTICE OF THE CONSULTING ENGINEERS
9. COVER SHOULDER BARS SHALL BE ANCHORED INTO COLUMN UP-TO A LENGTH EQUAL TO 50X BAR DIA. MEASURED FROM COLUMN FACE
10. BARS TO BE CUT & BENT NEAR OPENINGS/POCKETS.

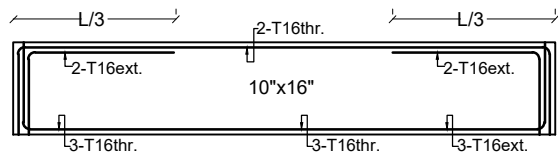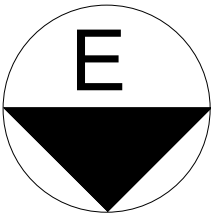

**TYP. BEAM SECTION**  
Rings 8mm@ (5"+8"+5") c/c for all beams

| BEAM<br>MKD | SIZE |     | REINFORCEMENT |              |             |              | STIRRUPS |          |
|-------------|------|-----|---------------|--------------|-------------|--------------|----------|----------|
|             |      |     | TOP REINF.    |              | BOT. REINF. |              |          |          |
|             | B    | D   | TOP.M (t1)    | TOP.EXT (t2) | BOT.M (b1)  | BOT.EXT (b2) | S1       | S2       |
| A1          | 10"  | 15" | 2-T16         | 2-T16        | 3-T16       | 3-T16        | T8@5"c/c | T8@5"c/c |

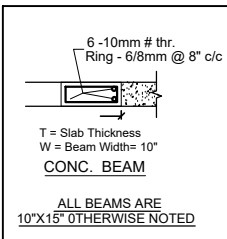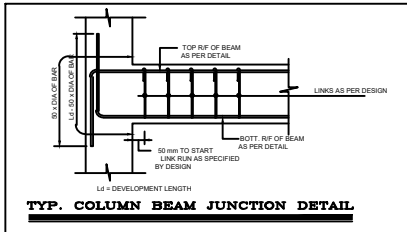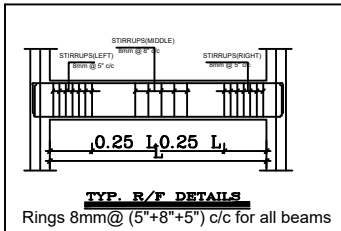

THIS DRAWING HAS NOT BEEN PUBLISHED AND IS THE SOLE PROPERTY OF  
PURPOSE AS STATED IN THE AGREEMENT AND IT SHALL NOT BE REPRODUCED,  
COPIED, LENT OR OTHERWISE DISPOSED OF DIRECTLY OR INDIRECTLY, NOR USED  
FOR ANY OTHER PURPOSE OTHER THAN FOR WHICH IT IS FURNISHED.  
ALL DIMENSIONS ARE IN MILLIMETER UNLESS OTHERWISE SPECIFIED.

MR.SUBODH KUMAR (CHIRAURA,AIIMS

## FIRST FLOOR SLAB BEAM

|    |
|----|
| 01 |
|----|


100

Er. Jayprakash kuma

Jaypro infratech Pvt. Ltd

Office Address: 1st Floor, Pandooi  
Place, Boring Road, Patna- 80001

E-mail id: [info@jayproinfratech.com](mailto:info@jayproinfratech.com), [www.jayproinfratech.com](http://www.jayproinfratech.com), Call Now: 9835852462,7277008312,

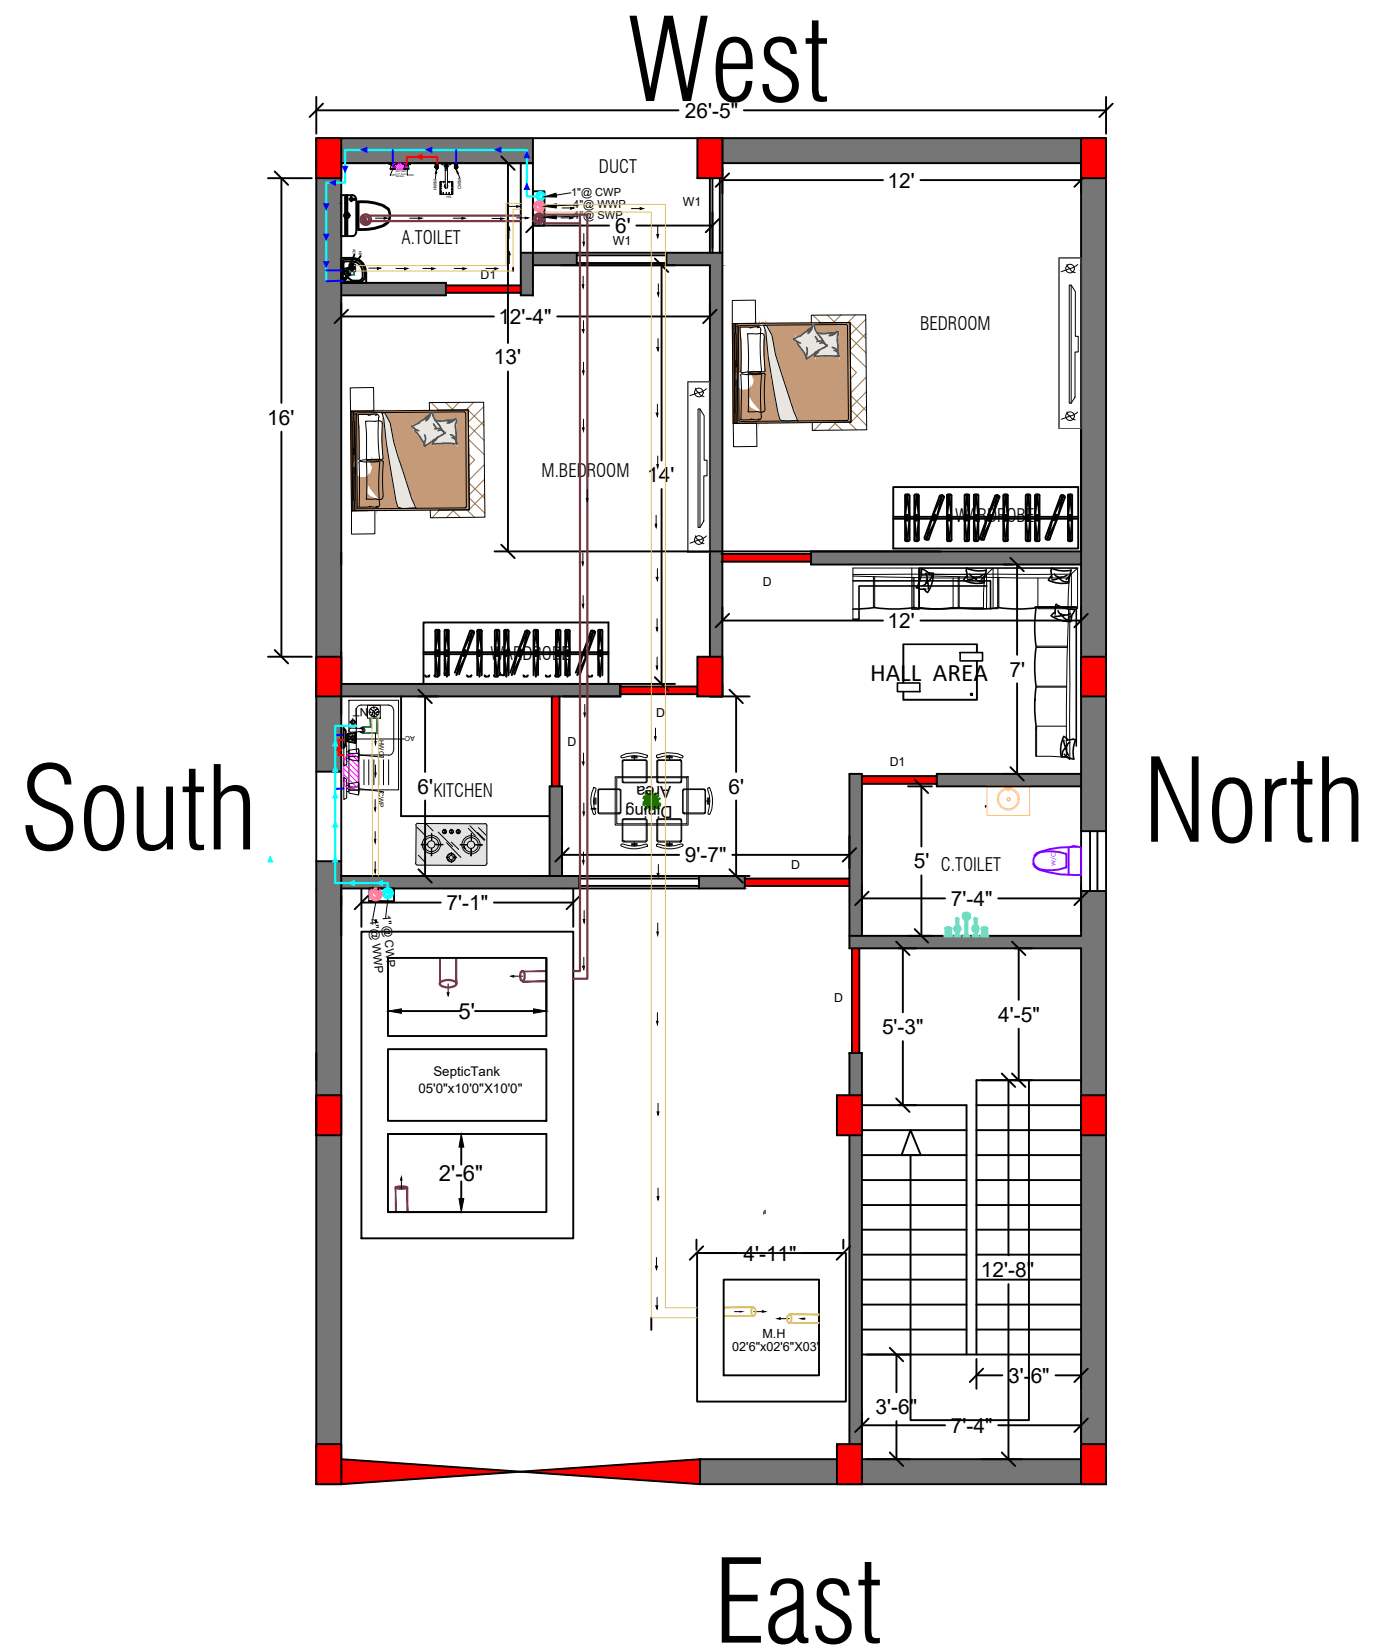

JAYPRO INFRATECH PVT.LTD.

#### Our Services

Architecture Design  
Structure Design  
Interior Design  
Estimating & Costing  
Building Construction With Material

#### LEGEND:-

NT- ANTI  
AC- ANGLE COCK at 3' h  
AC/HF- ANGLE COCK/HEALTH FAUCET GUN at 2' h  
CWI- COLD WATER IN at 7' h  
HWO- HOT WATER OUT at 7' h  
HWM- HOT WATER MIXER at 4' h  
CWM- COLD WATER MIXER at 4' h  
TAP- TAP at 3' h  
HS- HEAD SHOWER at 7' h  
BT- BOTTLE TRAP  
MP- METROPOLE FLUSH at 3' h  
AC-HW- ANGLE COCK FOR HOT WATER at 2' h  
AC-CW- ANGLE COCK FOR COLD WATER at 2' h  
BT - BOTTLE TRAP  
RWP- RAIN WATER PIPE  
1/2"@ COLD WATER PIPE - SH-40 UPVC  
3/4"@ HOT WATER PIPE - CPVC SDR - 11 PIPE  
1"@ COLD WATER PIPE - UPVC PIPE  
2 1/2"@ WASTE WATER PIPE - 6KG/CM2 PVC FOR WASH BASIN  
4"@ WASTE WATER LINE - 6KG/CM2 PVC PIPE  
6"@ SOIL WATER LINE - 6KG/CM2 PVC PIPE  
RISER - 2"@ COLD WATER DOWNTAKE -SH - 40 PVC PIPE  
CWP - 2"@ COLD WATER PIPE - SH-40 PVC  
WWP - 4"@ WASTE WATER PIPE -PVC 6 KG/CM2  
SWP - 6"@ SOIL WATER PIPE -PVC 6 KG/CM2

E

THIS DRAWING HAS NOT BEEN PUBLISHED AND IS THE SOLE PROPERTY OF PURPOSE AS STATED IN THE AGREEMENT AND IT SHALL NOT BE REPRODUCED, COPIED, LENT OR OTHERWISE DISPOSED OF DIRECTLY OR INDIRECTLY, NOR USED FOR ANY OTHER PURPOSE OTHER THAN FOR WHICH IT IS FURNISHED. ALL DIMENSIONS ARE IN MILLIMETER UNLESS OTHERWISE SPECIFIED.

CLIENT :-

MR.SUBODH KUMAR (CHIRAURA,AIIMS)

PROJECT :-

Ground Floor plumbing design

SCALE:-

1:100

Plan Number:-

11

ISSUED

5.09.25

Design By

 
Ar. Soni Kumari

Checked By

Er. Jayprakash Kumar

Approved By

Jaypro Infratech Pvt.Ltd.



Jaypro Infratech Pvt.Ltd.

Office Address: 1st Floor, Pandooi Place, Boring Road, Patna- 80001

Follow Now :-

You Tube :- jaypro\_infratech

Facebook Page :- jaypro\_infratech

Insta Id :- jaypro\_infratech

E-Mail Id :- info@jayproinfratech.com,www.jayproinfratech.com,Call No:- 9835852462,7277008312,

Our Services

Architecture Design  
Structure Design  
Interior Design  
Estimating & Costing  
Building Construction With Material

LEGEND:-


- NT- ANTI  
AC- ANGLE COCK at 3' h  
AC/HF- ANGLE COCK/HEALTH FAUCET GUN at 2' h  
CWI- COLD WATER IN at 7' h  
HWO- HOT WATER OUT at 7' h  
HWM- HOT WATER MIXER at 4' h  
CWM- COLD WATER MIXER at 4' h  
TAP- TAP at 3' h  
HS- HEAD SHOWER at 7' h  
BT- BOTTLE TRAP  
MP- METROPOLE FLUSH at 3' h  
AC-HW- ANGLE COCK FOR HOT WATER at 2' h  
AC-CW- ANGLE COCK FOR COLD WATER at 2' h  
BT - BOTTLE TRAP  
RWP- RAIN WATER PIPE  
1/2"@ COLD WATER PIPE - SH-40 UPVC  
3/4"@ HOT WATER PIPE - CPVC SDR - 11 PIPE  
1"@ COLD WATER PIPE - UPVC PIPE  
2 1/2"@ WASTE WATER PIPE - 6KG/CM2 PVC FOR WASH BASIN  
4"@ WASTE WATER LINE - 6KG/CM2 PVC PIPE  
6"@ SOIL WATER LINE - 6KG/CM2 PVC PIPE  
RISER - 2"@ COLD WATER DOWNTAKE -SH - 40 PVC PIPE  
CWP - 2"@ COLD WATER PIPE - SH-40 PVC  
WWP - 4"@ WASTE WATER PIPE -PVC 6 KG/CM2  
SWP - 6"@ SOIL WATER PIPE -PVC 6 KG/CM2

E

THIS DRAWING HAS NOT BEEN PUBLISHED AND IS THE SOLE PROPERTY OF PURPOSE AS STATED IN THE AGREEMENT AND IT SHALL NOT BE REPRODUCED, COPIED, LENT OR OTHERWISE DISPOSED OF DIRECTLY OR INDIRECTLY, NOR USED FOR ANY OTHER PURPOSE OTHER THAN FOR WHICH IT IS FURNISHED. ALL DIMENSIONS ARE IN MILLIMETER UNLESS OTHERWISE SPECIFIED.


CLIENT :- MR.SUBODH KUMAR (CHIRAURA,IIIMS)

 PROJECT :- First Floor plumbing design

|               |                           |                                                                                       |         |
|---------------|---------------------------|---------------------------------------------------------------------------------------|---------|
| SCALE:-       | 1:100                     | ISSUED                                                                                | 5.09.25 |
| Plan Number:- | 11                        |                                                                                       |         |
| Design By     | Ar. Soni Kumari           |  |         |
| Checked By    | Er. Jayprakash Kumar      |                                                                                       |         |
| Approved By   | Jaypro Infratech Pvt.Ltd. |                                                                                       |         |

Jaypro Infratech Pvt.Ltd.

Office Address: 1st Floor, Pandooi Place, Boring Road, Patna- 80001

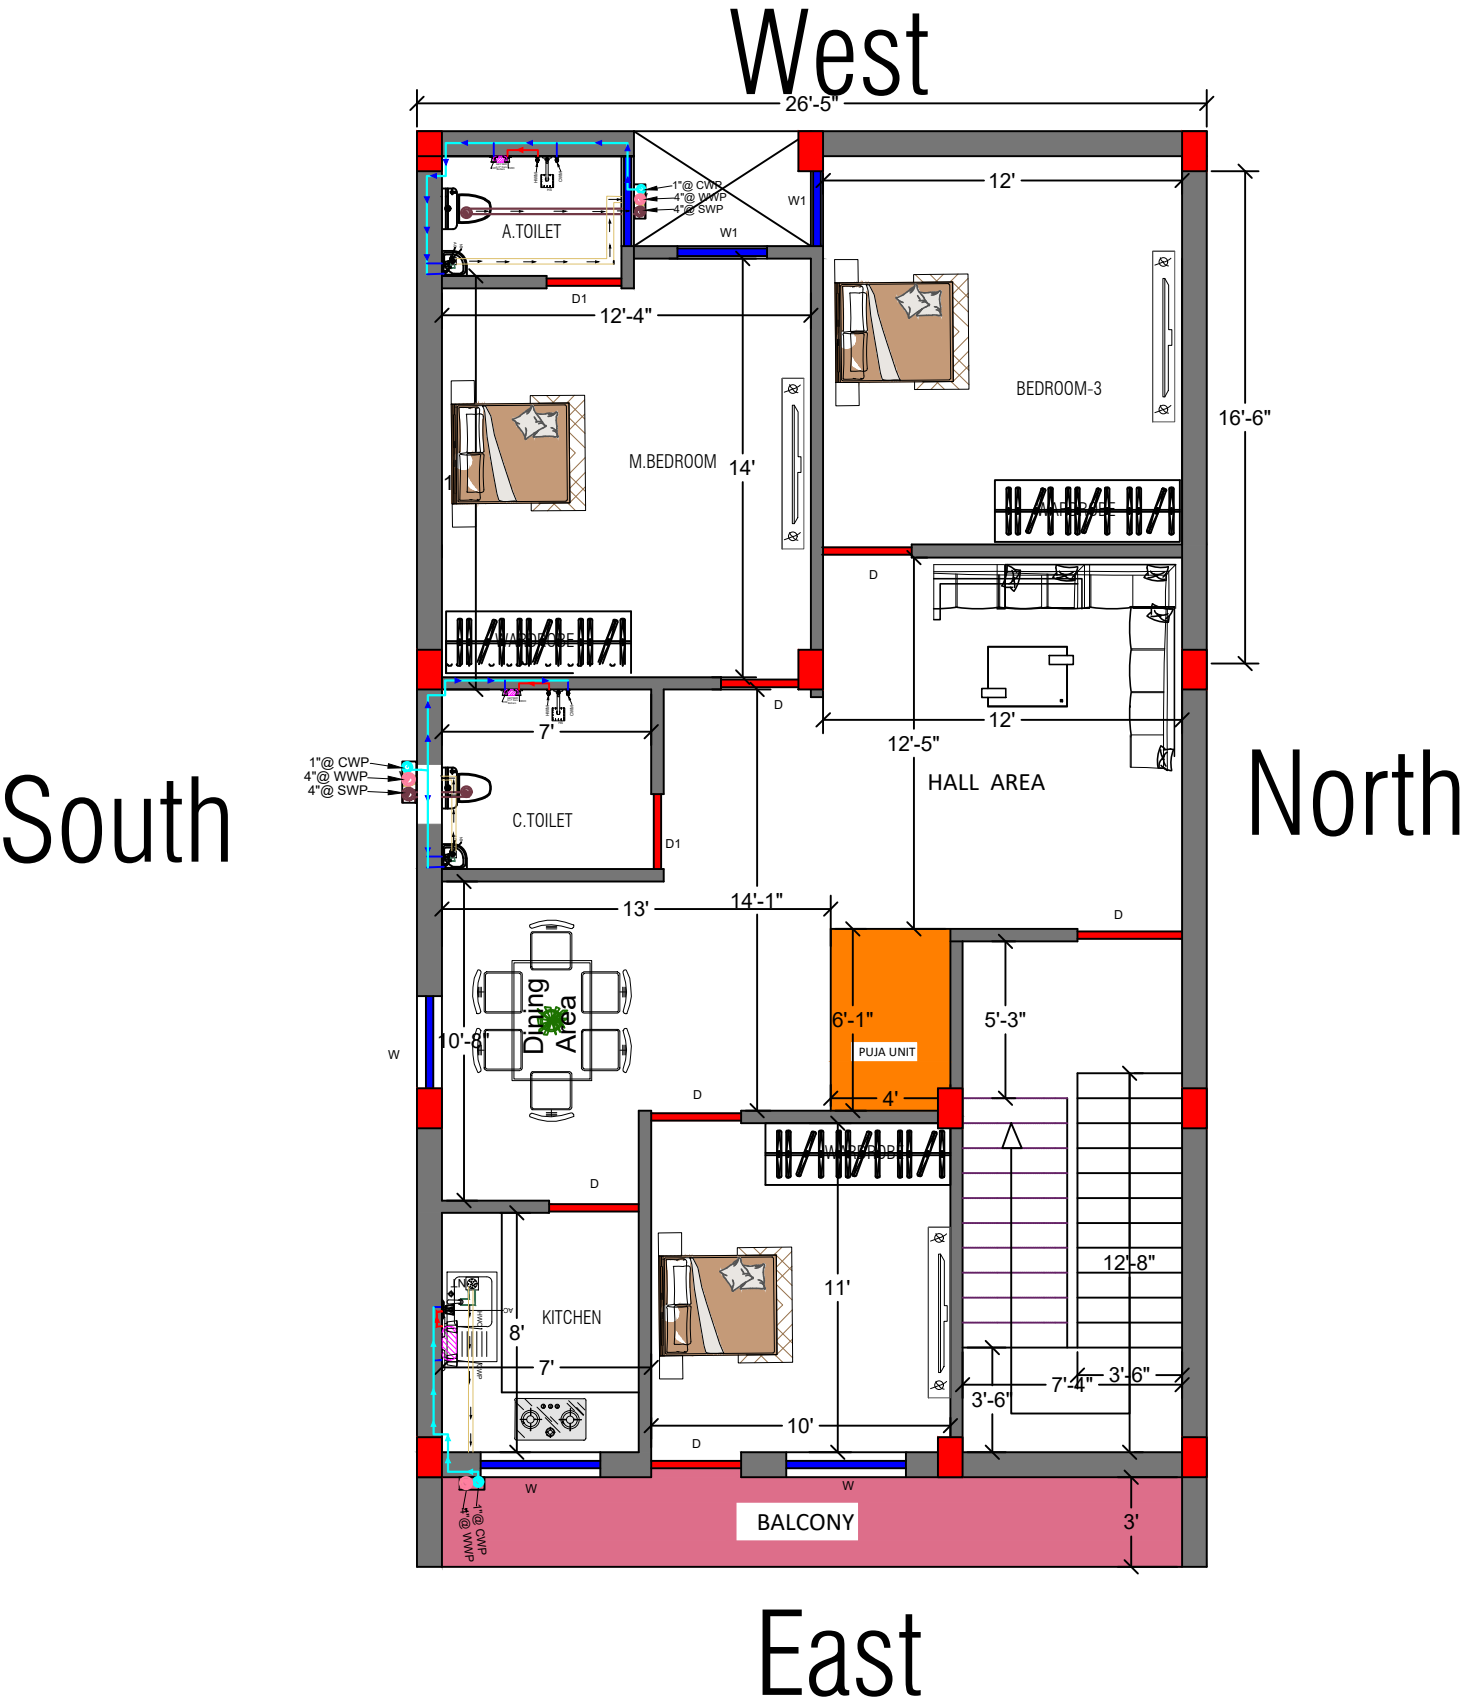


Follow Now :-

You Tube :- jaypro\_infratech  
Facebook Page :- jaypro\_infratech  
Insta Id :- jaypro\_infratech

E-Mail Id :- info@jayproinfratech.com,www.jayproinfratech.com,Call No:- 9835852462,7277008312,

Our Services

Architecture Design  
Structure Design  
Interior Design  
Estimating & Costing  
Building Construction With Material

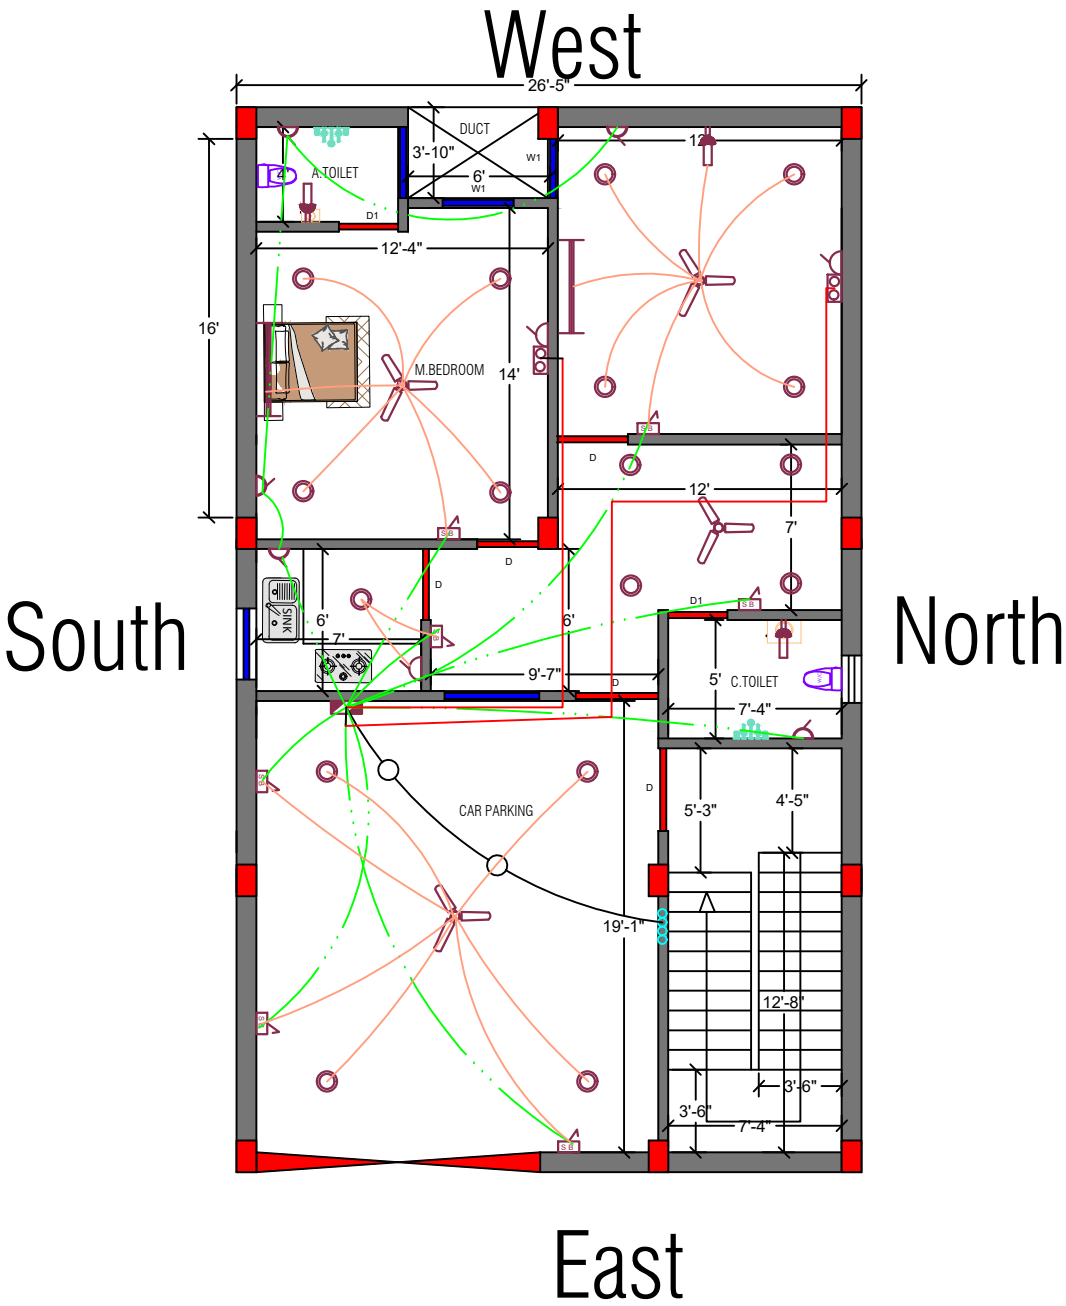

LEGEND

| SYMBOL | DESCRIPTION                    | HEIGHT     |
|--------|--------------------------------|------------|
|        | CEILING FAN                    | ON CEILING |
|        | CHANDELIAR LIGHT POINT         | ON CEILING |
|        | 40WX40" TUBE LIGHT FITTING     | 8'6"       |
|        | BLUB                           | 8'6"       |
|        | NIGHT BLUB                     | 8'6"       |
|        | C.F.L.                         | ON CEILING |
|        | SPORT LIGHT                    | ON CEILING |
|        | CEILING LIGHT                  | ON CEILING |
|        | FLASH JUNCTION BOX             | ON CEILING |
|        | SWITCH BOARD                   | 4'6" HT    |
|        | BED SWITCH                     | 2'6" HT    |
|        | TWO WAY SWITCH                 | ON SWITCH  |
|        | 5 AMPS SWITCH SOEKET           | 1'6" HT    |
|        | 15 AMPS SWITCH SOEKET          | 1'6" HT    |
|        | 25 AMPS SWITCH SOEKET (A.C)    | 1'6" HT    |
|        | CALL BELL BUZZER               | 1'6" HT    |
|        | CALL BELL PUSH                 | 4'6" HT    |
|        | OUT LET FOR TELEPHONE          | 1'6" HT    |
|        | OUT LET FOR TV                 | 1'6" HT    |
|        | EXHAUST FAN (IN TOI & KIT)     |            |
|        | TABLE LAMP                     |            |
|        | ROOT OF TV TELEPHONE WIRING    |            |
|        | ROOT OF POINT WIRING (25MM)    |            |
|        | ROOT OF POINT WIRING (19MM)    |            |
|        | ROOT OF CIRCUIT WIRING (19MM)  |            |
|        | ROOT OF SUB MAIN WIRING (25MM) |            |
|        | WALL FAN                       |            |
|        | DISTRIBUTION BOARD             |            |
|        | METERING PANAL                 |            |

E

THIS DRAWING HAS NOT BEEN PUBLISHED AND IS THE SOLE PROPERTY OF PURPOSE AS STATED IN THE AGREEMENT AND IT SHALL NOT BE REPRODUCED, COPIED, LENT OR OTHERWISE DISPOSED OF DIRECTLY OR INDIRECTLY, NOR USED FOR ANY OTHER PURPOSE OTHER THAN FOR WHICH IT IS FURNISHED. ALL DIMENSIONS ARE IN MILLIMETER UNLESS OTHERWISE SPECIFIED.

CLIENT :-

PROJECT :- Ground Floor Electric design

|               |                           |        |         |
|---------------|---------------------------|--------|---------|
| SCALE:-       | 1:100                     | ISSUED | 3.07.25 |
| Plan Number:- | 11                        |        |         |
| Design By     | Ar. Soni Kumari           |        |         |
| Checked By    | Er. Jayprkash Kumar       |        |         |
| Approved By   | Jaypro Infratech Pvt.Ltd. |        |         |

Jaypro Infratech Pvt.Ltd.

Office Address: 1st Floor, Pandooi Place, Boring Road, Patna- 80001


Follow Now :-

You Tube :- jaypro\_infratech  
Facebook Page :- jaypro\_infratech  
Insta Id :- jaypro\_infratech

E-Mail Id :- info@jayproinfratech.com,www.jayproinfratech.com,Call No:- 9835852462,7277008312,

Our Services

Architecture Design  
Structure Design  
Interior Design  
Estimating & Costing  
Building Construction With Material

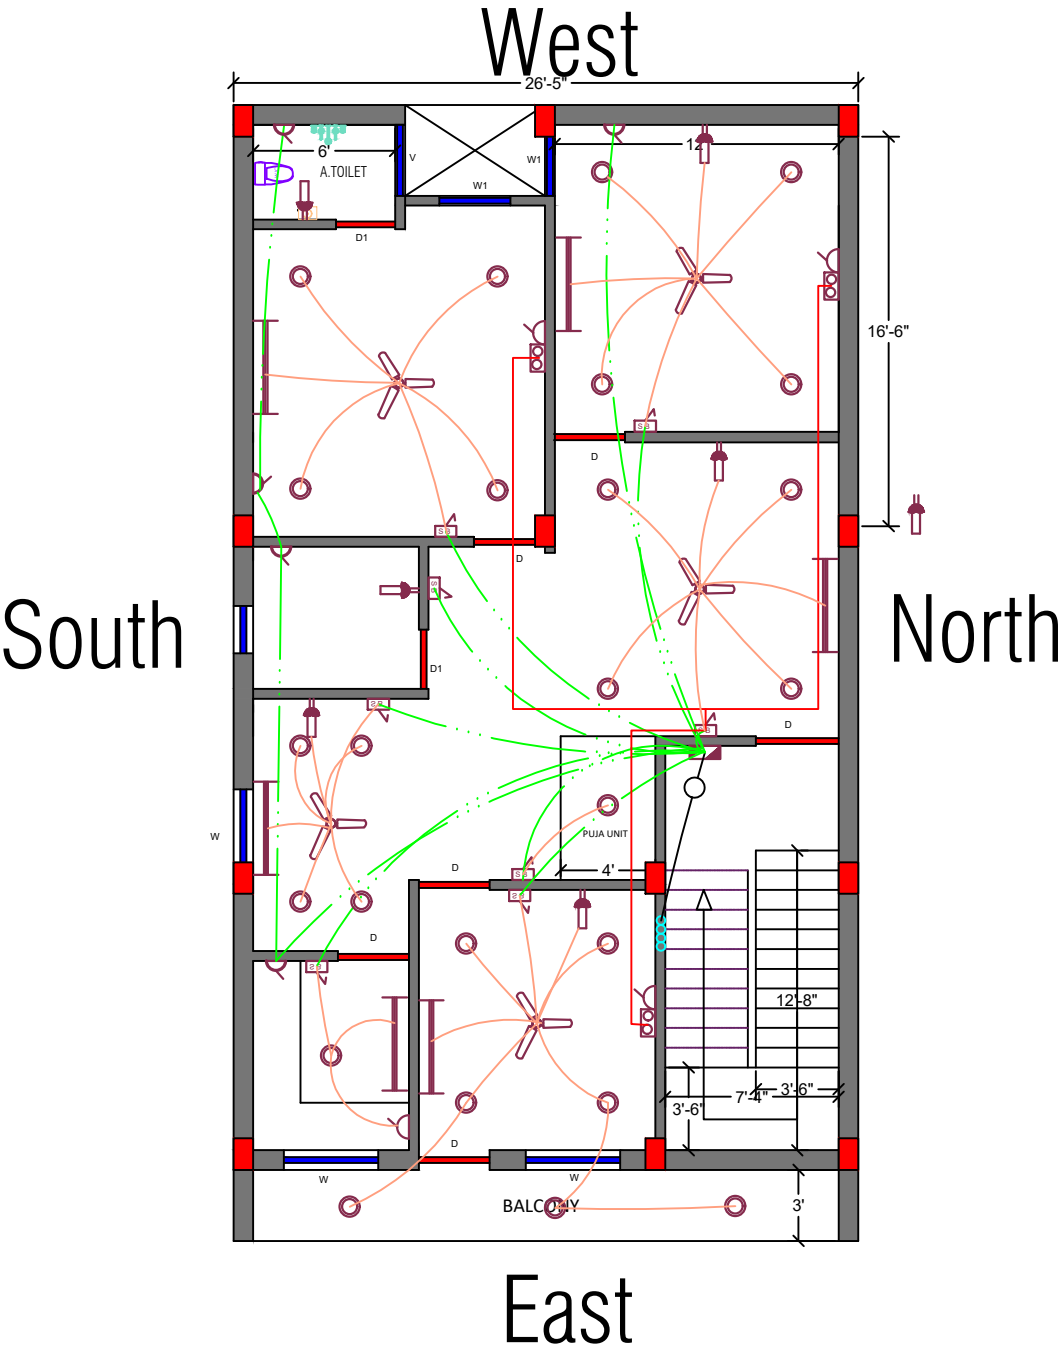

LEGEND

| SYMBOL | DESCRIPTION                    | HEIGHT     |
|--------|--------------------------------|------------|
|        | CEILING FAN                    | ON CEILING |
|        | CHANDELIER LIGHT POINT         | ON CEILING |
|        | 40WX40" TUBE LIGHT FITTING     | 8'6"       |
|        | BLUB                           | 8'6"       |
|        | NIGHT BLUB                     | 8'6"       |
|        | C.F.L.                         | ON CEILING |
|        | SPORT LIGHT                    | ON CEILING |
|        | CEILING LIGHT                  | ON CEILING |
|        | FLASH JUNCTION BOX             | ON CEILING |
|        | SWITCH BOARD                   | 4'6" HT    |
|        | BED SWITCH                     | 2'6" HT    |
|        | TWO WAY SWITCH                 | ON SWITCH  |
|        | 5 AMPS SWITCH SOEKET           | 1'6" HT    |
|        | 15 AMPS SWITCH SOEKET          | 1'6" HT    |
|        | 25 AMPS SWITCH SOEKET (A.C)    | 1'6" HT    |
|        | CALL BELL BUZZER               | 1'6" HT    |
|        | CALL BELL PUSH                 | 4'6" HT    |
|        | OUT LET FOR TELEPHONE          | 1'6" HT    |
|        | OUT LET FOR TV                 | 1'6" HT    |
|        | EXHAUST FAN (IN TOI & KIT)     |            |
|        | TABLE LAMP                     |            |
|        | ROOT OF TV TELEPHONE WIRING    |            |
|        | ROOT OF POINT WIRING (25MM)    |            |
|        | ROOT OF POINT WIRING (19MM)    |            |
|        | ROOT OF CIRCUIT WIRING (19MM)  |            |
|        | ROOT OF SUB MAIN WIRING (25MM) |            |
|        | WALL FAN                       |            |
|        | DISTRIBUTION BOARD             |            |
|        | METERING PANAL                 |            |

E

THIS DRAWING HAS NOT BEEN PUBLISHED AND IS THE SOLE PROPERTY OF PURPOSE AS STATED IN THE AGREEMENT AND IT SHALL NOT BE REPRODUCED, COPIED, LENT OR OTHERWISE DISPOSED OF DIRECTLY OR INDIRECTLY, NOR USED FOR ANY OTHER PURPOSE OTHER THAN FOR WHICH IT IS FURNISHED. ALL DIMENSIONS ARE IN MILLIMETER UNLESS OTHERWISE SPECIFIED.

CLIENT :-

PROJECT :- First Floor Electric design

|               |                           |        |         |
|---------------|---------------------------|--------|---------|
| SCALE:-       | 1:100                     | ISSUED | 3.07.25 |
| Plan Number:- | 11                        |        |         |
| Design By     | Ar. Soni Kumari           |        |         |
| Checked By    | Er. Jayprkash Kumar       |        |         |
| Approved By   | Jaypro Infratech Pvt.Ltd. |        |         |

Jaypro Infratech Pvt.Ltd.

Office Address: 1st Floor, Pandooi Place, Boring Road, Patna- 80001

Follow Now :-

You Tube :- jaypro\_infratech  
Facebook Page :- jaypro\_infratech  
Insta Id :- jaypro\_infratech

E-Mail Id :- info@jayproinfratech.com,www.jayproinfratech.com,Call No:- 9835852462,7277008312,